



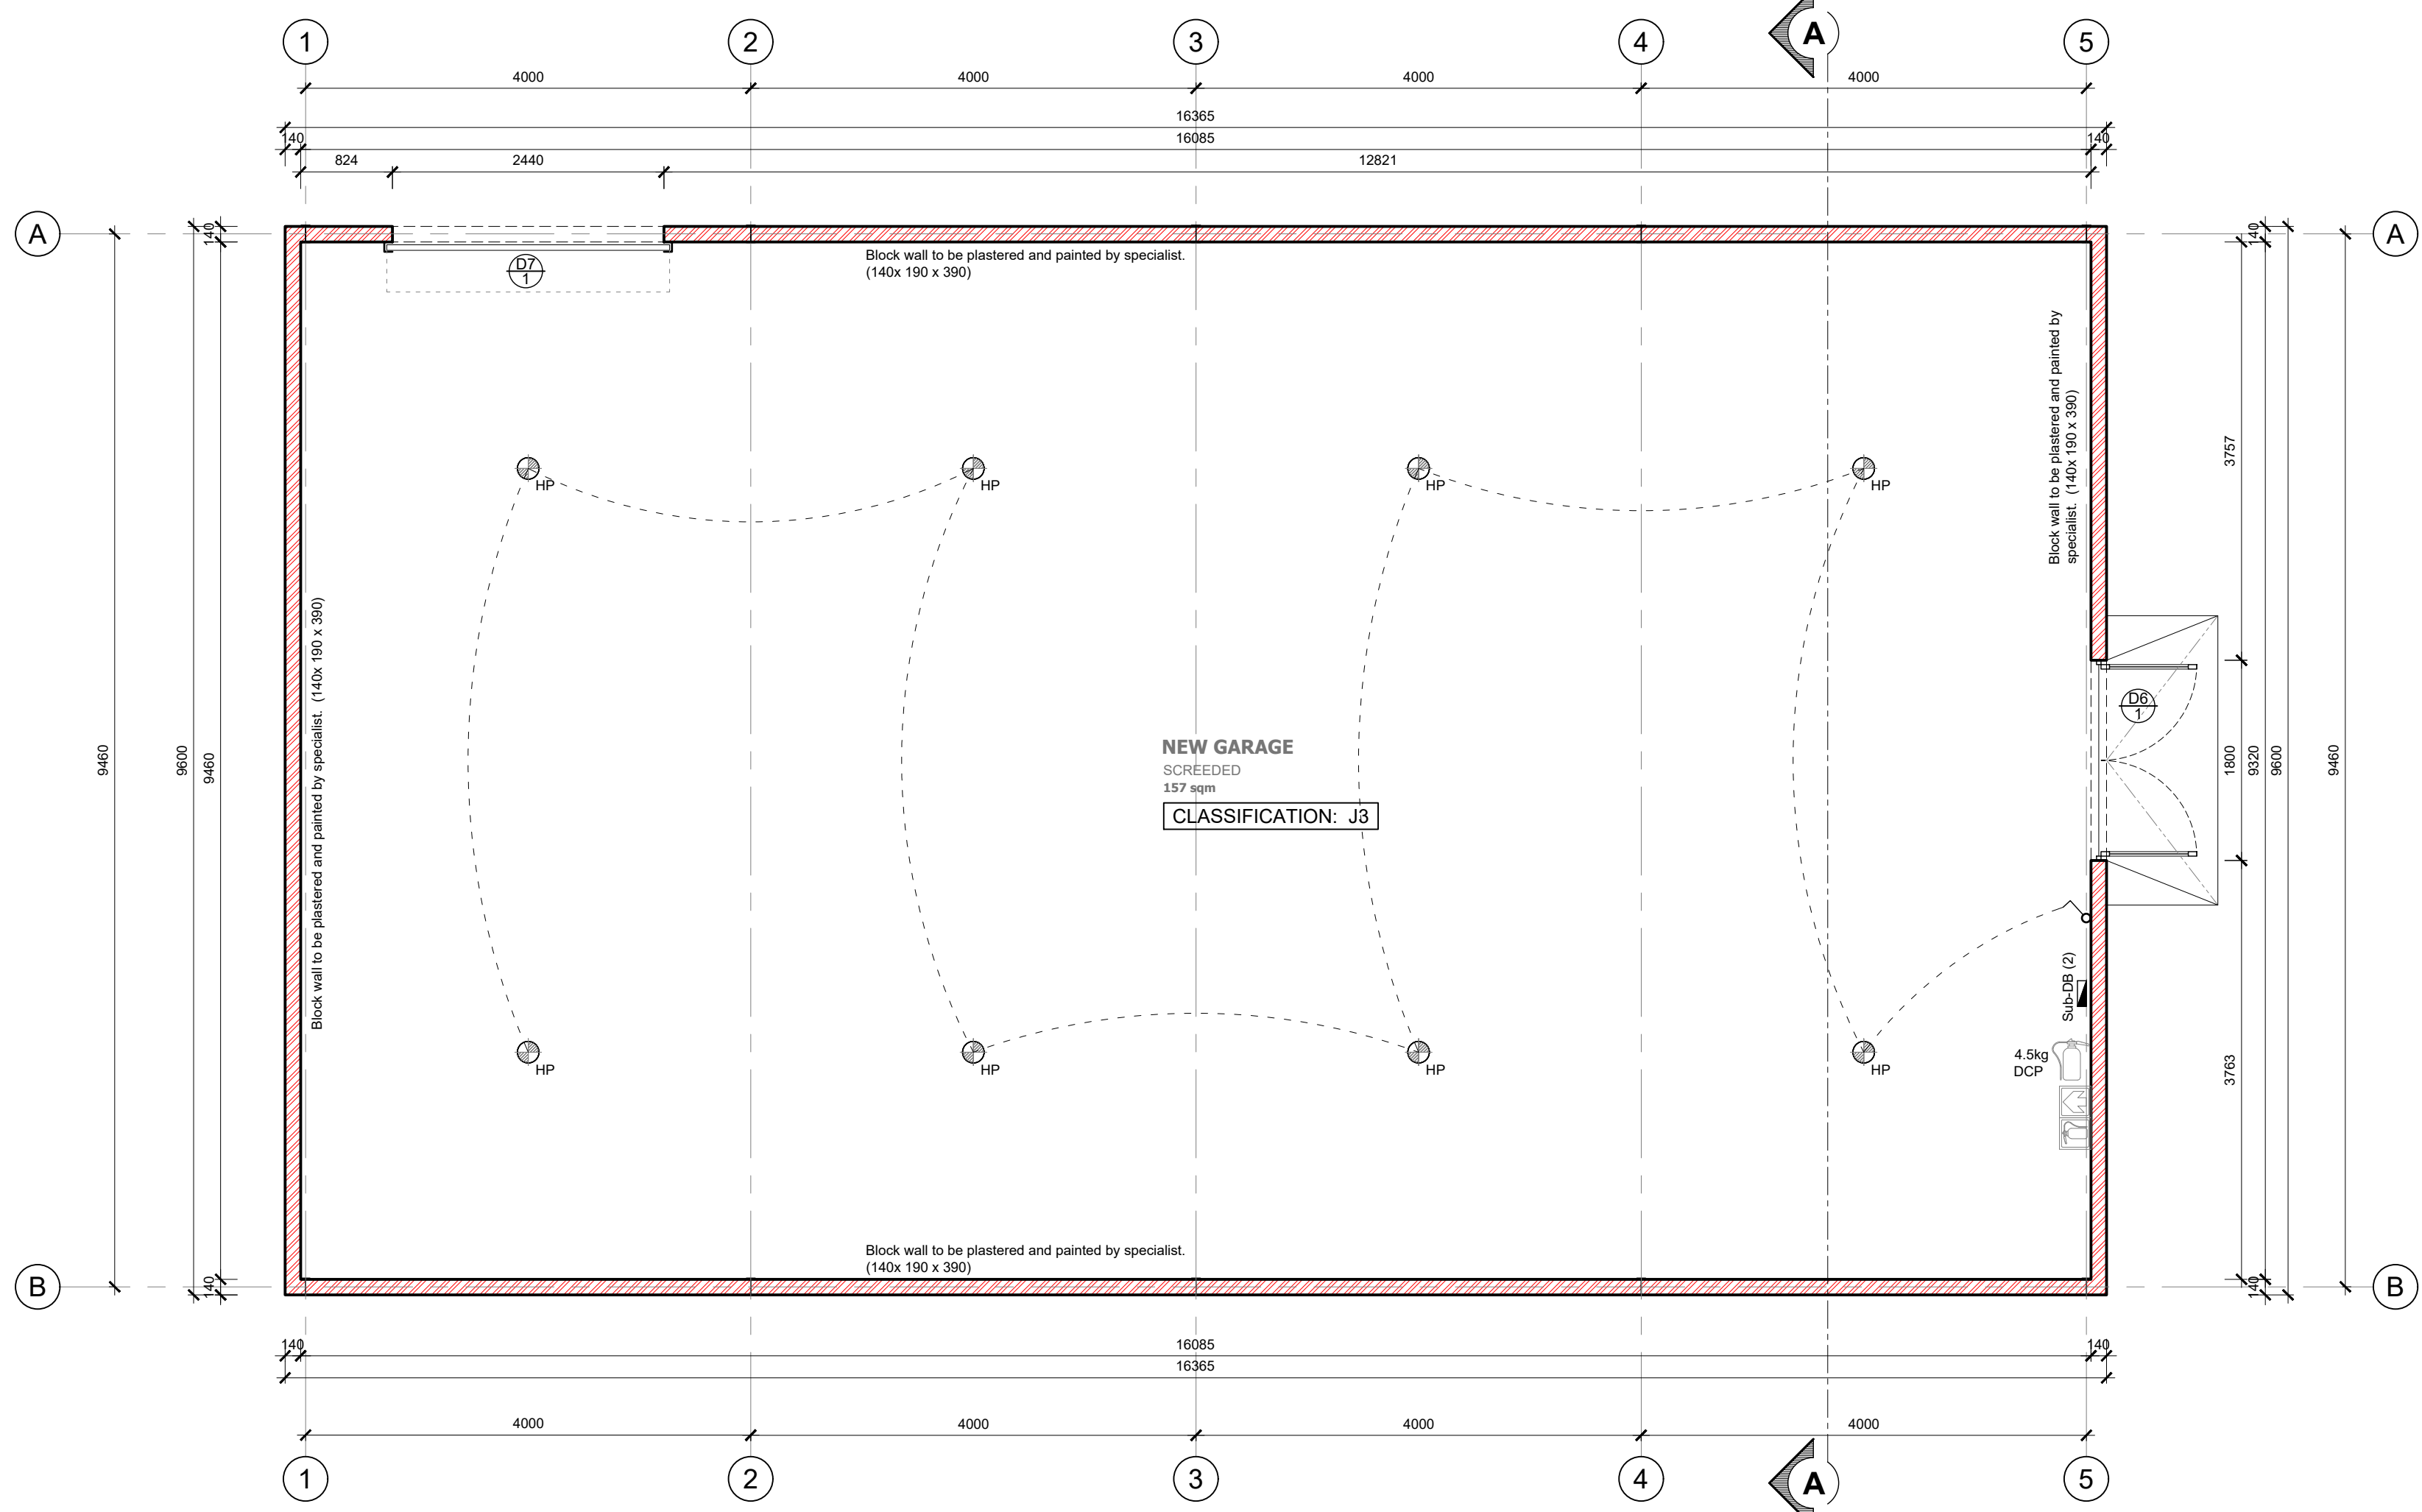


FLOOR PLAN / NEW TRACTOR GARAGE

SCALE 1:50

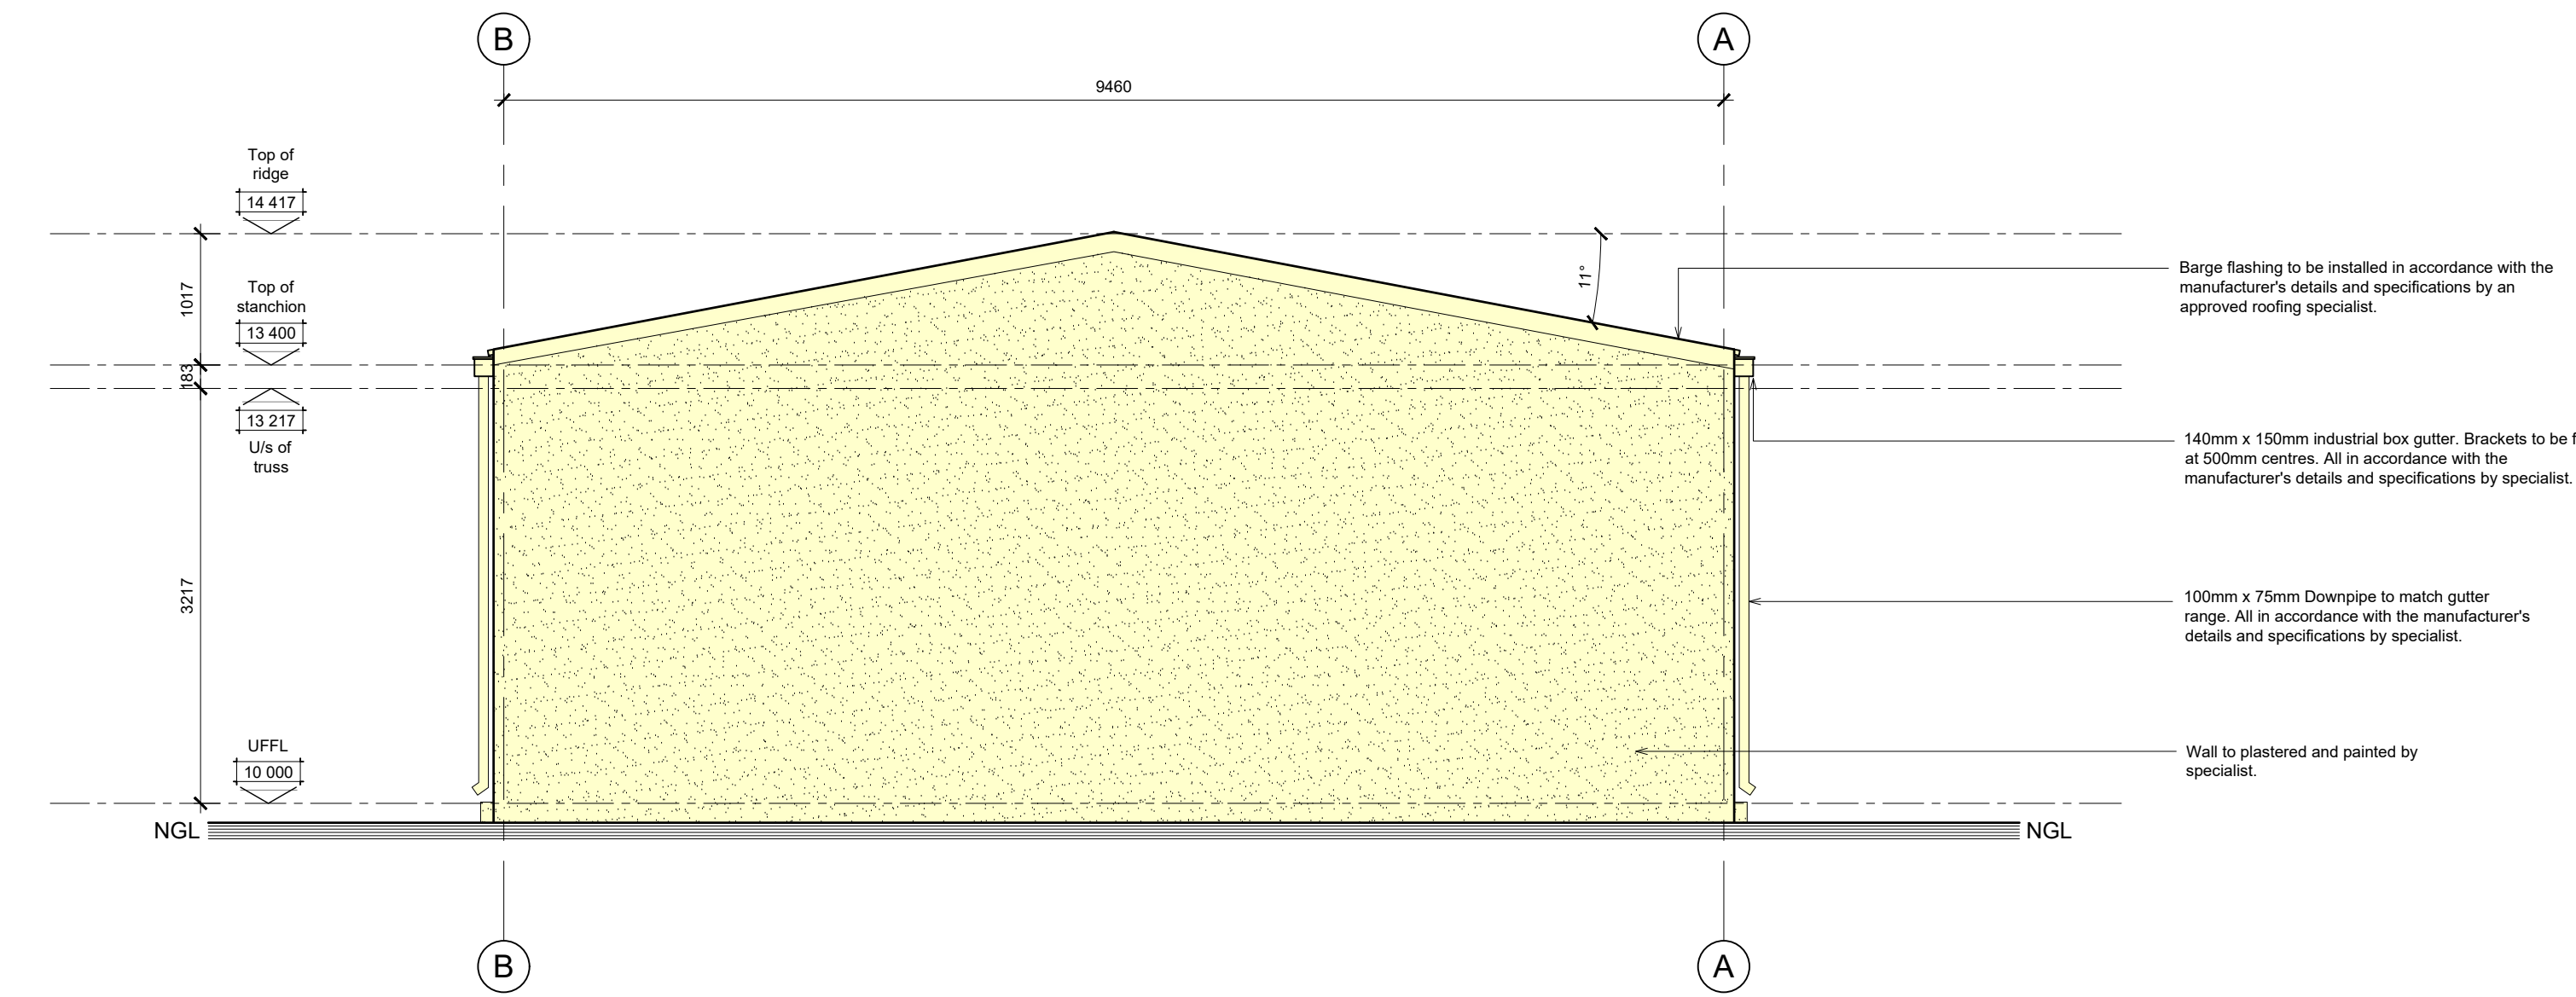


NORTH ELEVATION / NEW TRACTOR GARAGE
SCALE 1:50

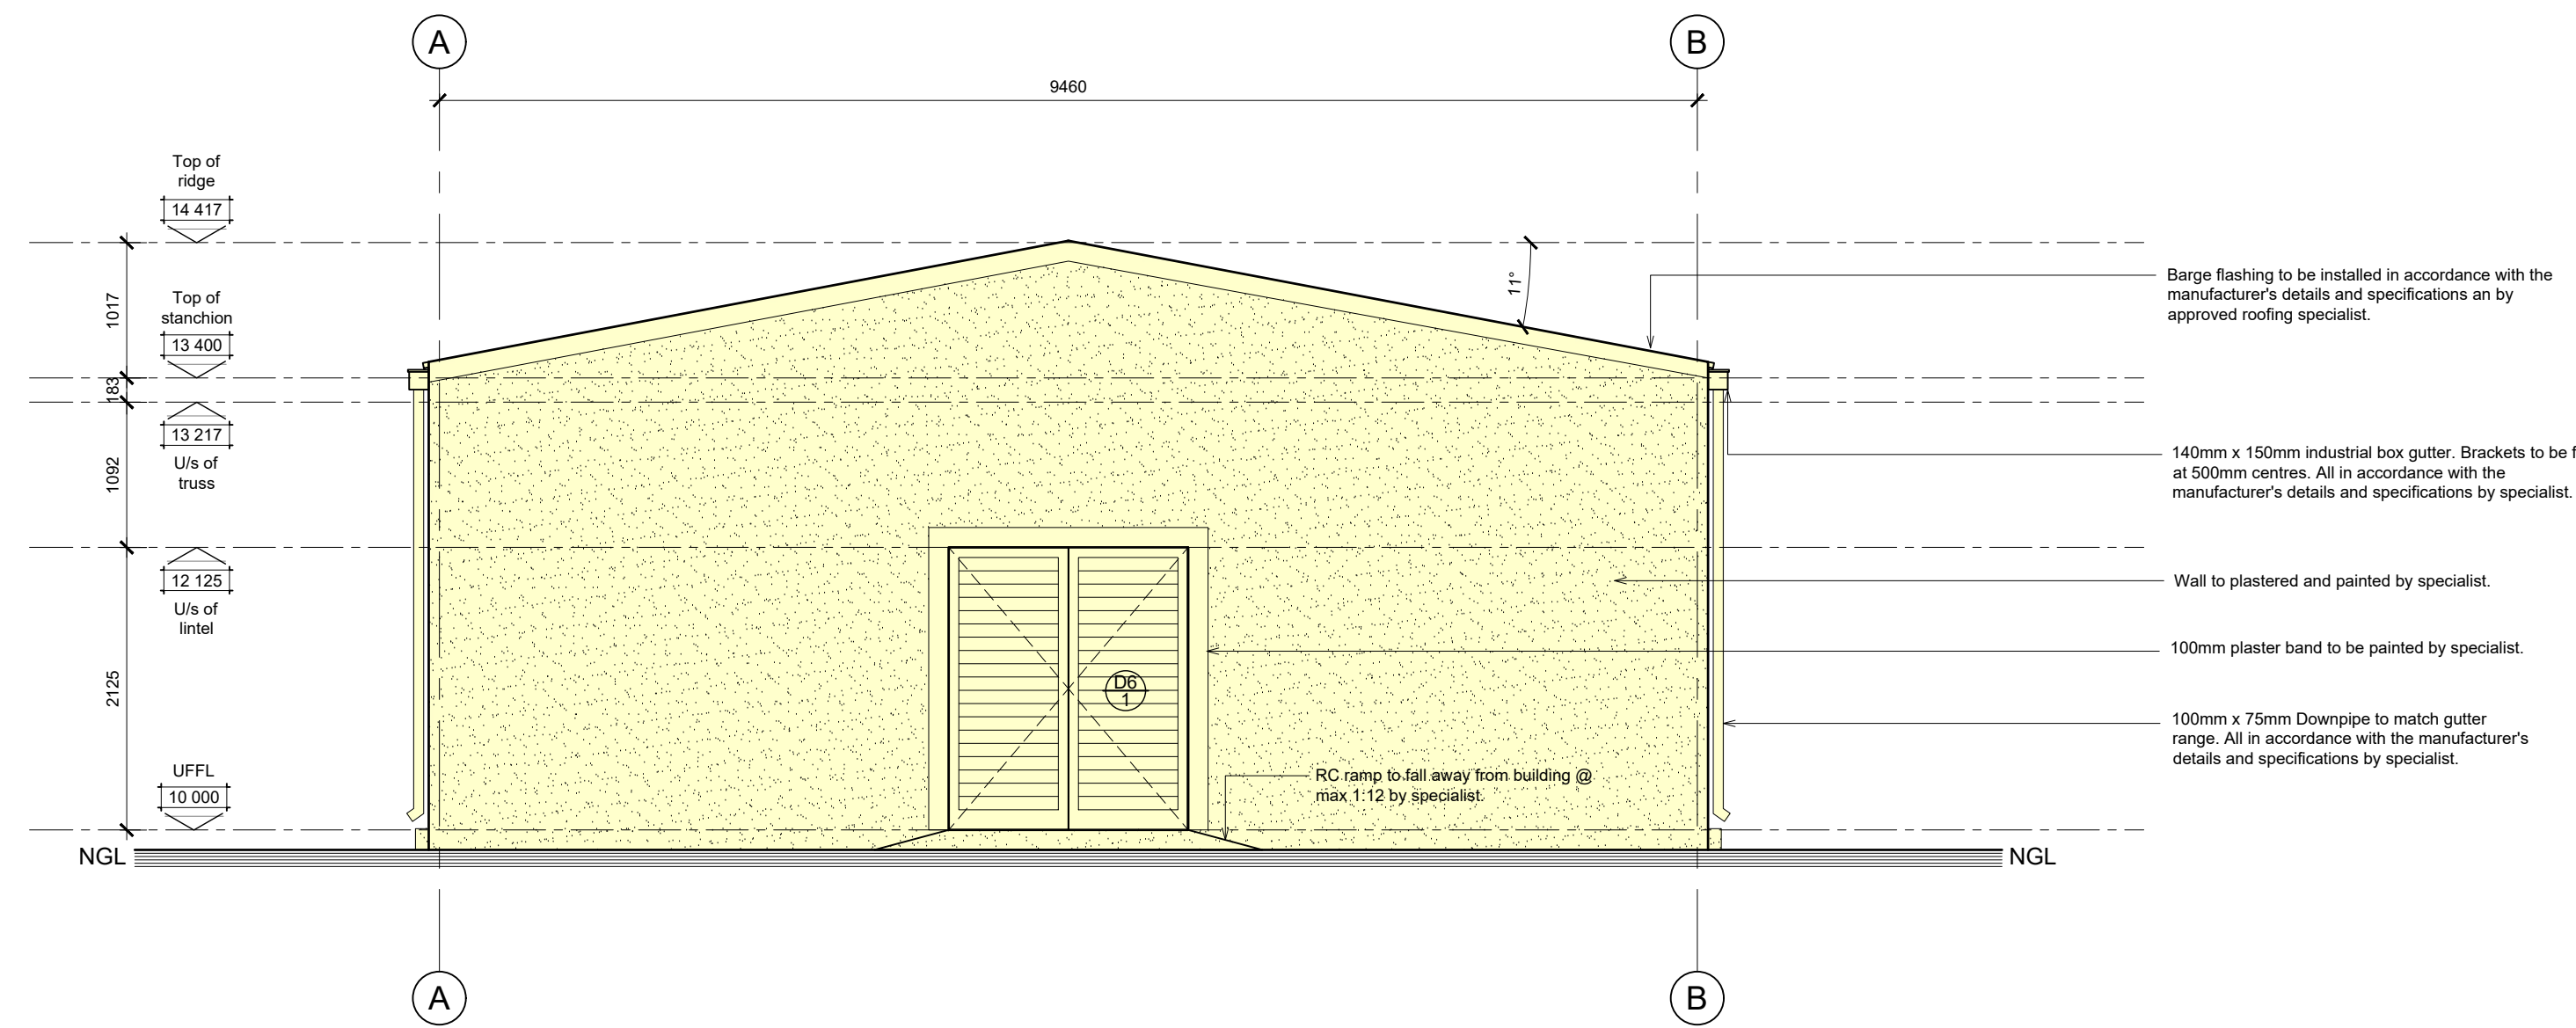


SOUTH ELEVATION / NEW TRACTOR GARAGE
SCALE 1:50

ELECTRICAL LEGEND	
LED Down lighter as per client specification	Periscope pipe as per specification
Single wall mounted light switch	Periscope door ceiling mounted motor
Double wall mounted light switch	TV point socket
Single wall mounted light switch to be connected at 300mm above wall	Shower plug
Double wall mounted light switch to be connected at 300mm above wall	Shower point
Double wall mounted light switch to be connected at 1300mm above wall	Network point
Double wall mounted light switch to be connected at 1300mm above wall	Drain shower
Double wall mounted light switch to be connected at 1300mm above wall	Power Sinking
Double wall mounted light switch to be connected at 1300mm above wall	Drain x 1/2" 1000 Long 2 tube Runwater connection with 300mm above wall
Double wall mounted underfoot plug	50 watt LED Down lighter as per specification
Extractor connection pipe x 210mm	50 watt (copper) LED Internal LED wall mounted light as per specification
Water connecting boxes	10 watt x 2 Internal LED wall mounted light
Periscope pipe as per specification	10 watt x 2 External LED wall mounted light
	50 watt External LED wall mounted spotlight
	3 watt internal compact fluorescent x 10 watt LED mounting as per specification
	Emergency light mounted as per client
	LED Strip Lighting
	Pool light as per client
	1 foot light
	Electrical fence control box
	Gate Control Unit
	Pre-paid Electricity meter
	Ultrasonic sensor
	Intercom
	Intercom system
	Alarm

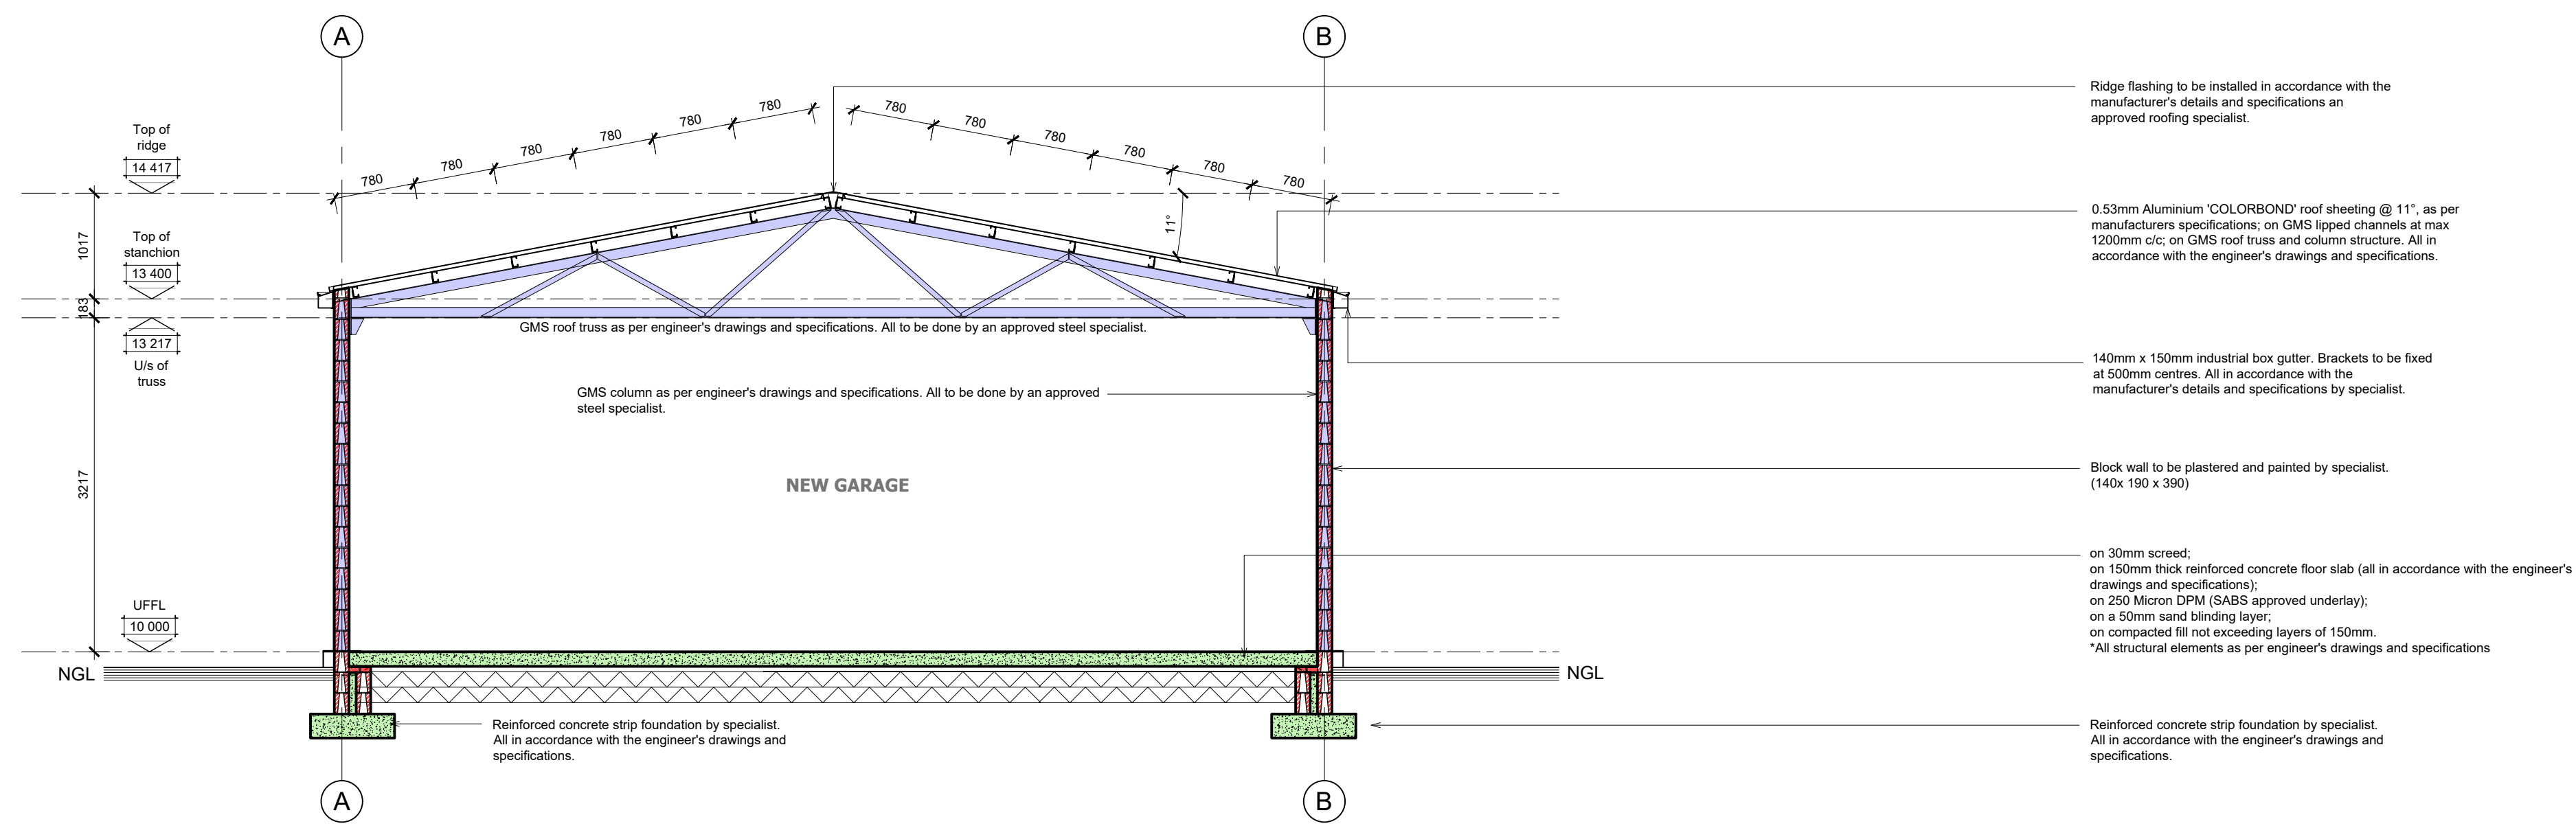


SECTION A-A / NEW TRACTOR GARAGE
SCALE 1:50

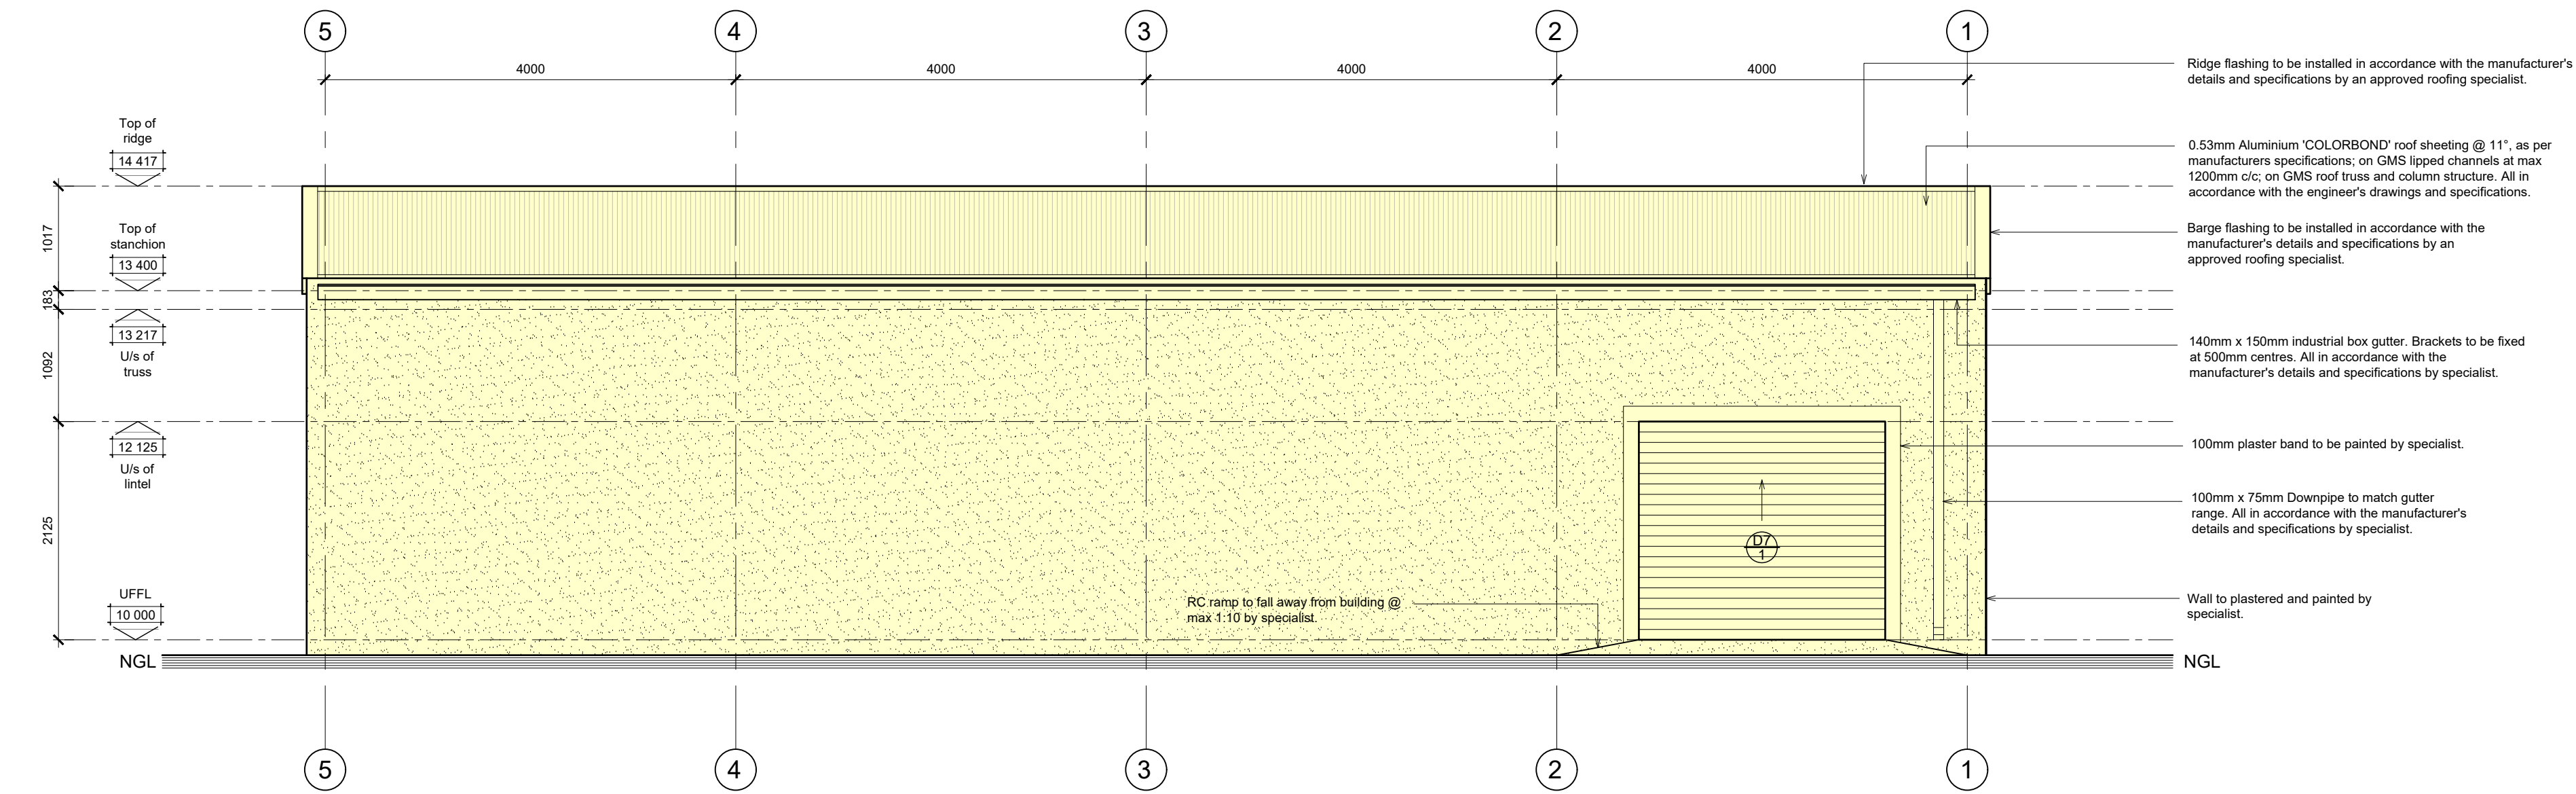

EAST ELEVATION / NEW TRACTOR GARAGE

SCALE 1:50

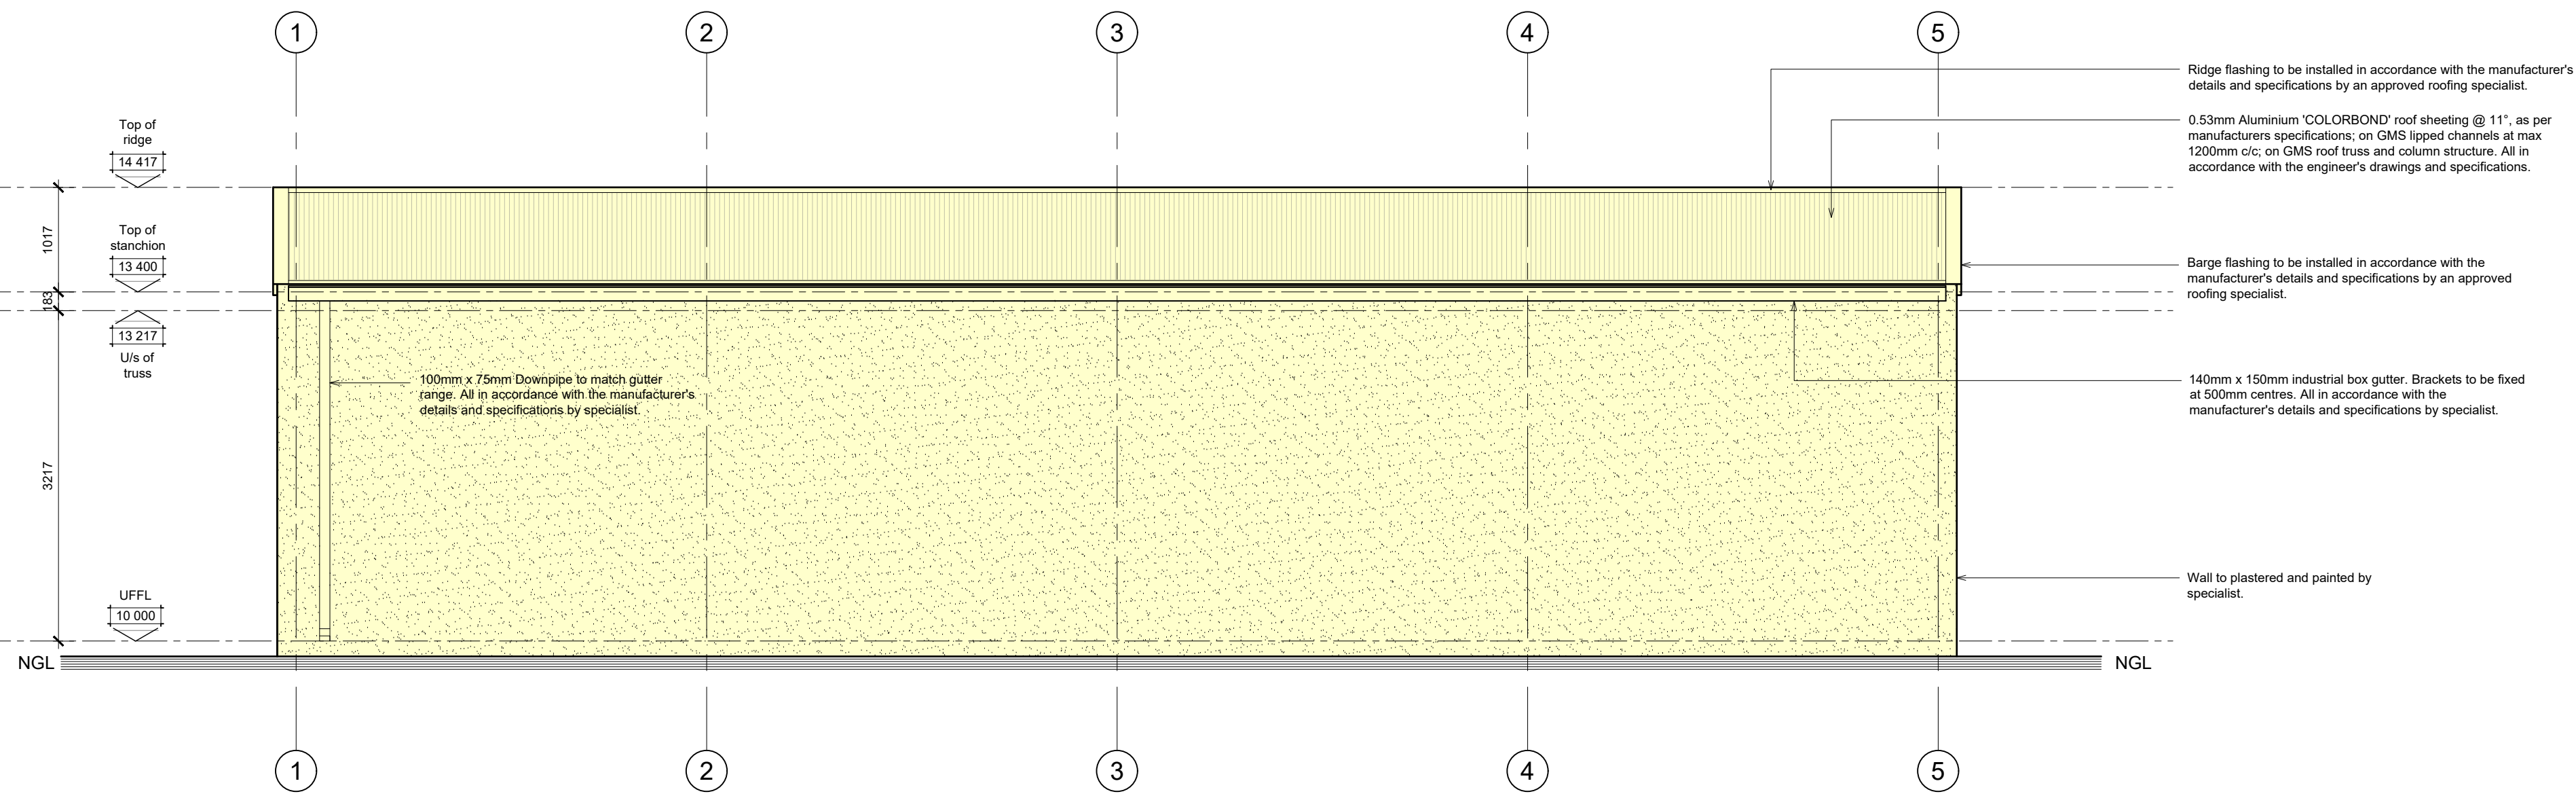

WEST ELEVATION / NEW TRACTOR GARAGE
SCALE 1:50

REVISIONS:

GENERAL NOTES:

[illegible]

DRAWING TITLE:

MUNICIPAL SUBMISSIONS

PROJECT TITLE:
ADDITIONS AND ALTERATIONS TO
DWELLING ON **ERF 2377, THEESCOMBE,**
PORT ELIZABETH FOR **Mr Saunders**

23 Nov 22
.....
CLIENT SIGNATURE

ch BLACKHOUND
ARCHITECTURE & RENDERING

dewald@blackhousedownterprises.com
072 799 9597 | 072 418 4861
 Unit 10, The Network, 19 Cactus Road
 Fairview, Port Elizabeth
 6073

23 Nov 22
.....
PROFESSIONAL SIGNATURE

MUNICIPAL INFORMATION:

EST NO:	2377, Theescombe
EIF AREA:	29005 sqm
EXISTING AREA:	531 sqm
NEW AREA:	278 sqm
TOTAL AREA:	809 sqm
EX. COVERAGE:	531 sqm - 2%
NEW COVERAGE:	278 sqm - 1%
TOTAL COVERAGE:	809 sqm - 3%
NEW GARAGES:	1
NEW BATHROOMS:	0
POOL:	NO
BOUNDARY WALLS:	0 M
AGE OF BUILDING:	26



COPYRIGHT:
This drawing is subject to copyright, and may not be reproduced in whole or part in any matter whatsoever without written permission from Blackboard Architecture & Rendering.

PROJECT NO.: 2022_STABLES	REVISION NO.: 00
DRAWING NO.: 20221110_STABLES_MS01	SHEET NO.: 101
DRAWN BY: DMP	
PRINT DATE: 23 Nov 2022	PAGE SIZE: A0