
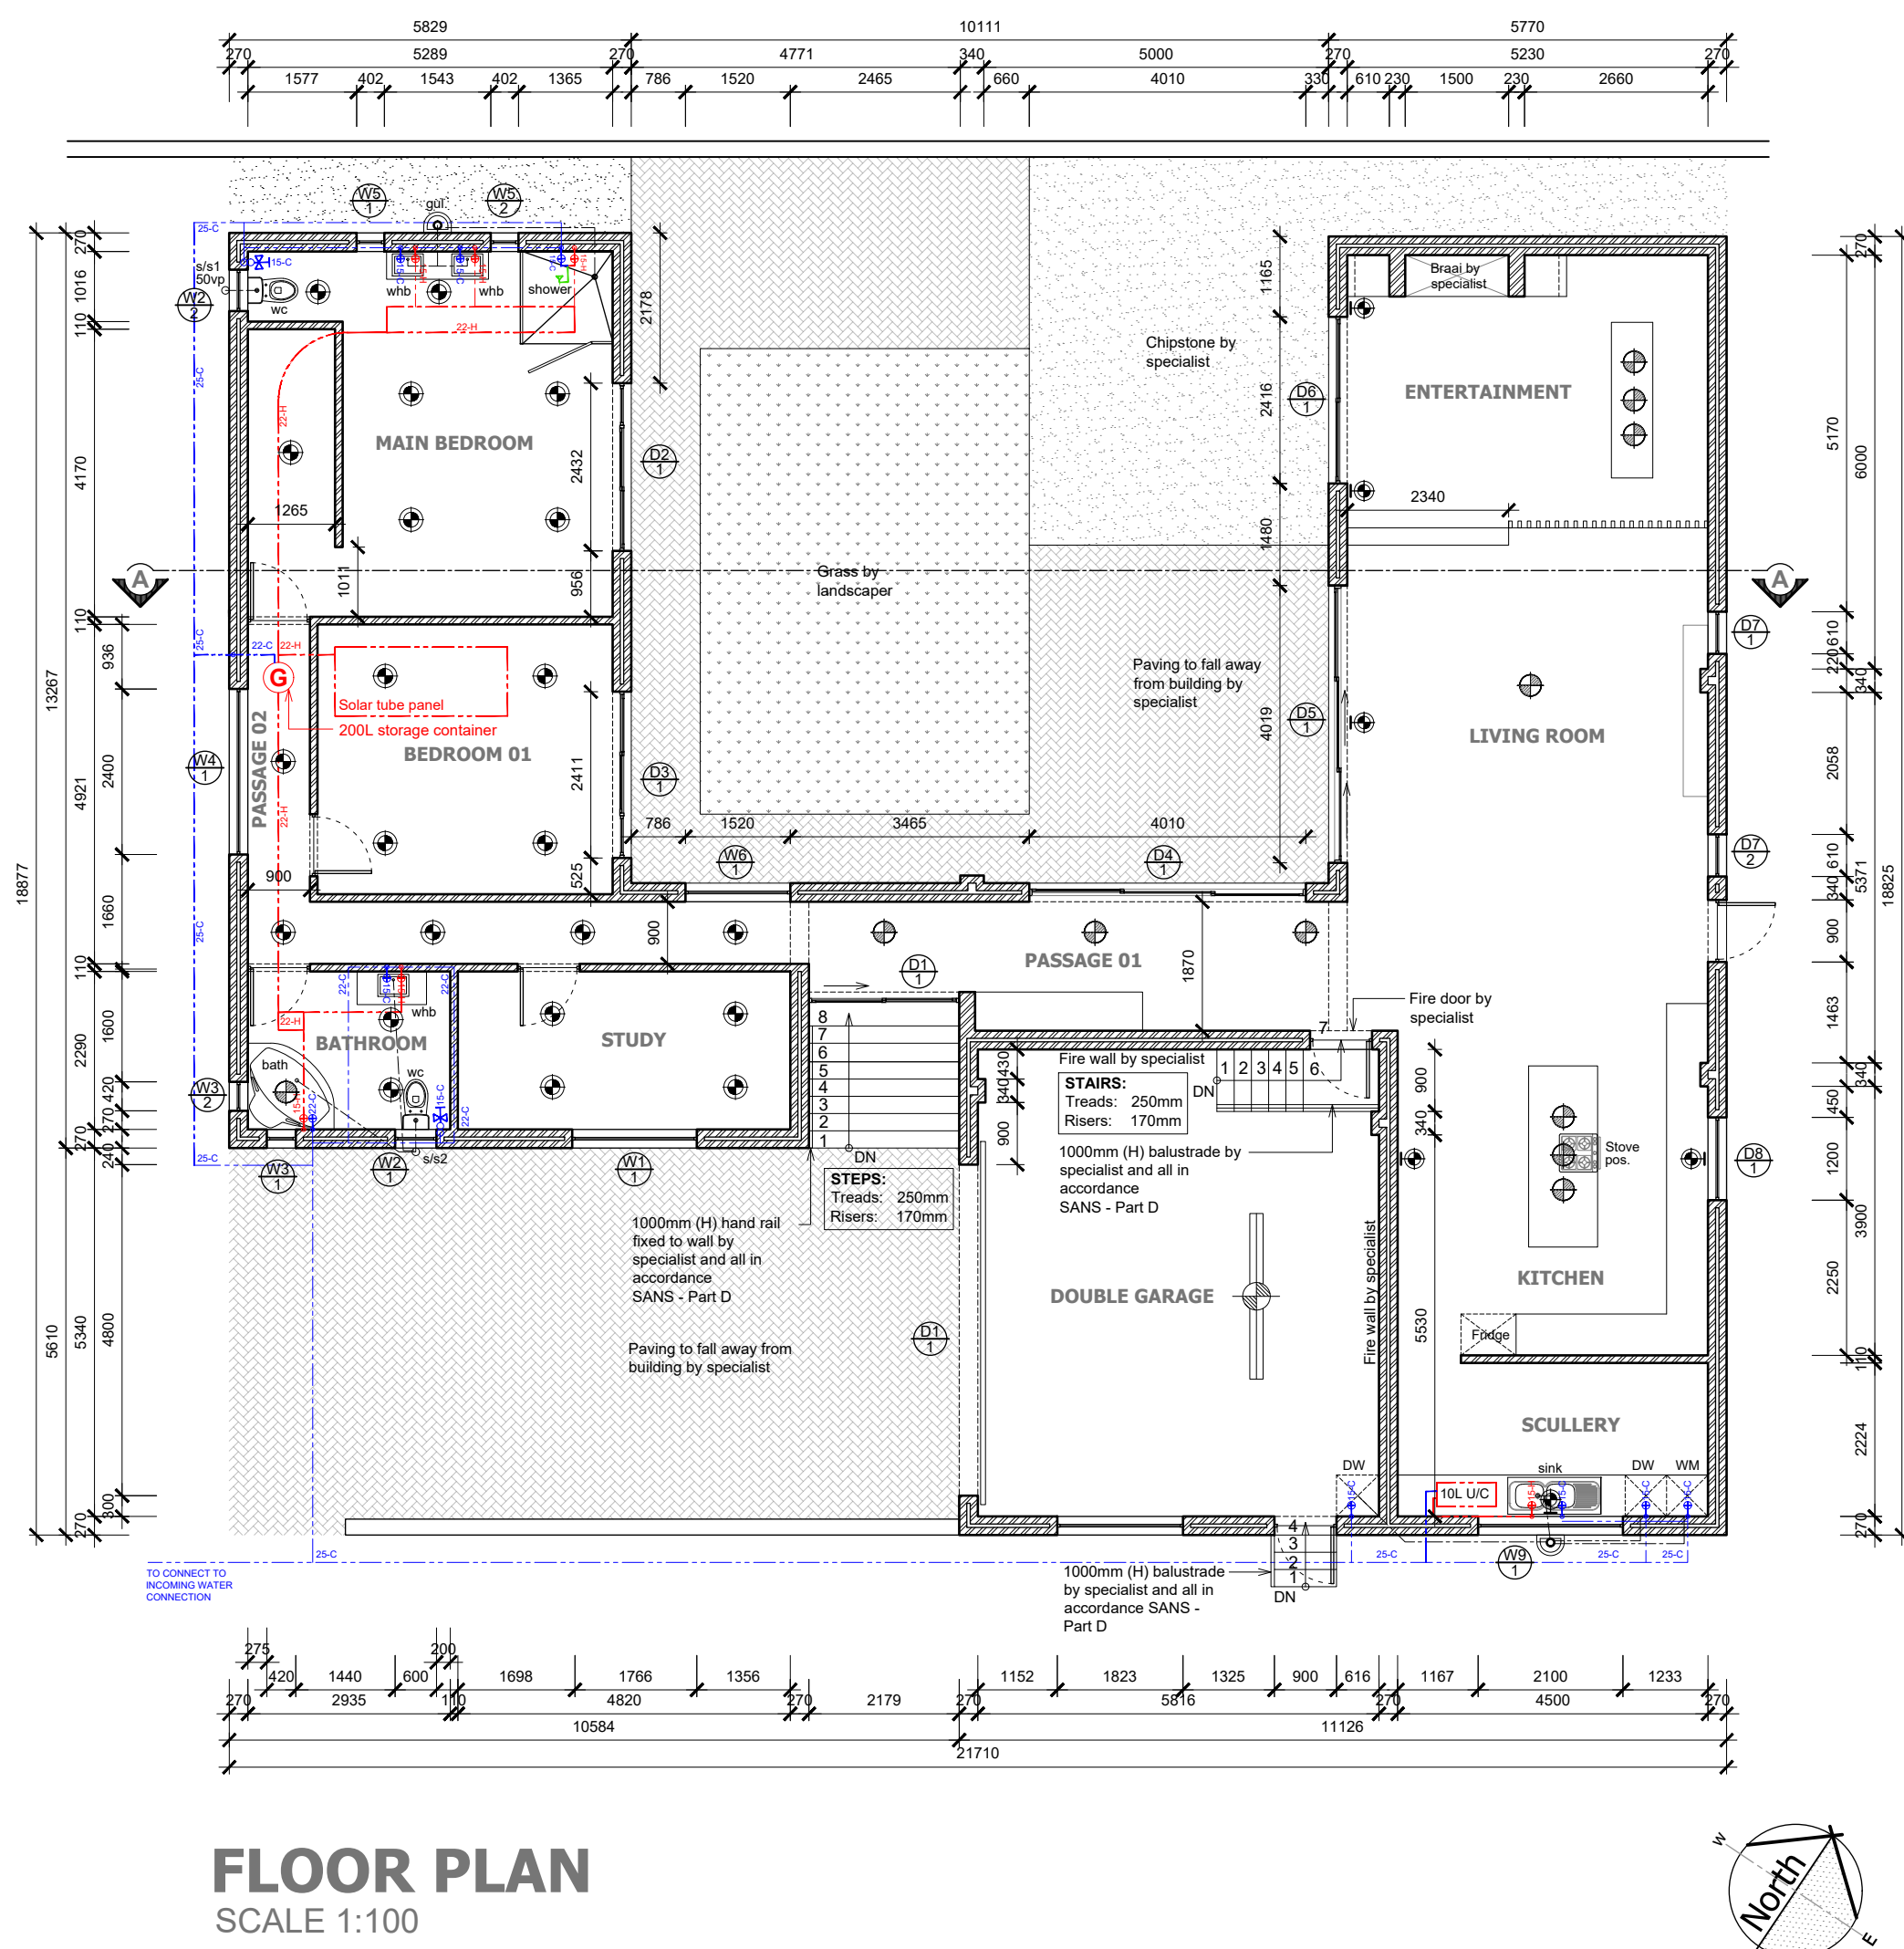
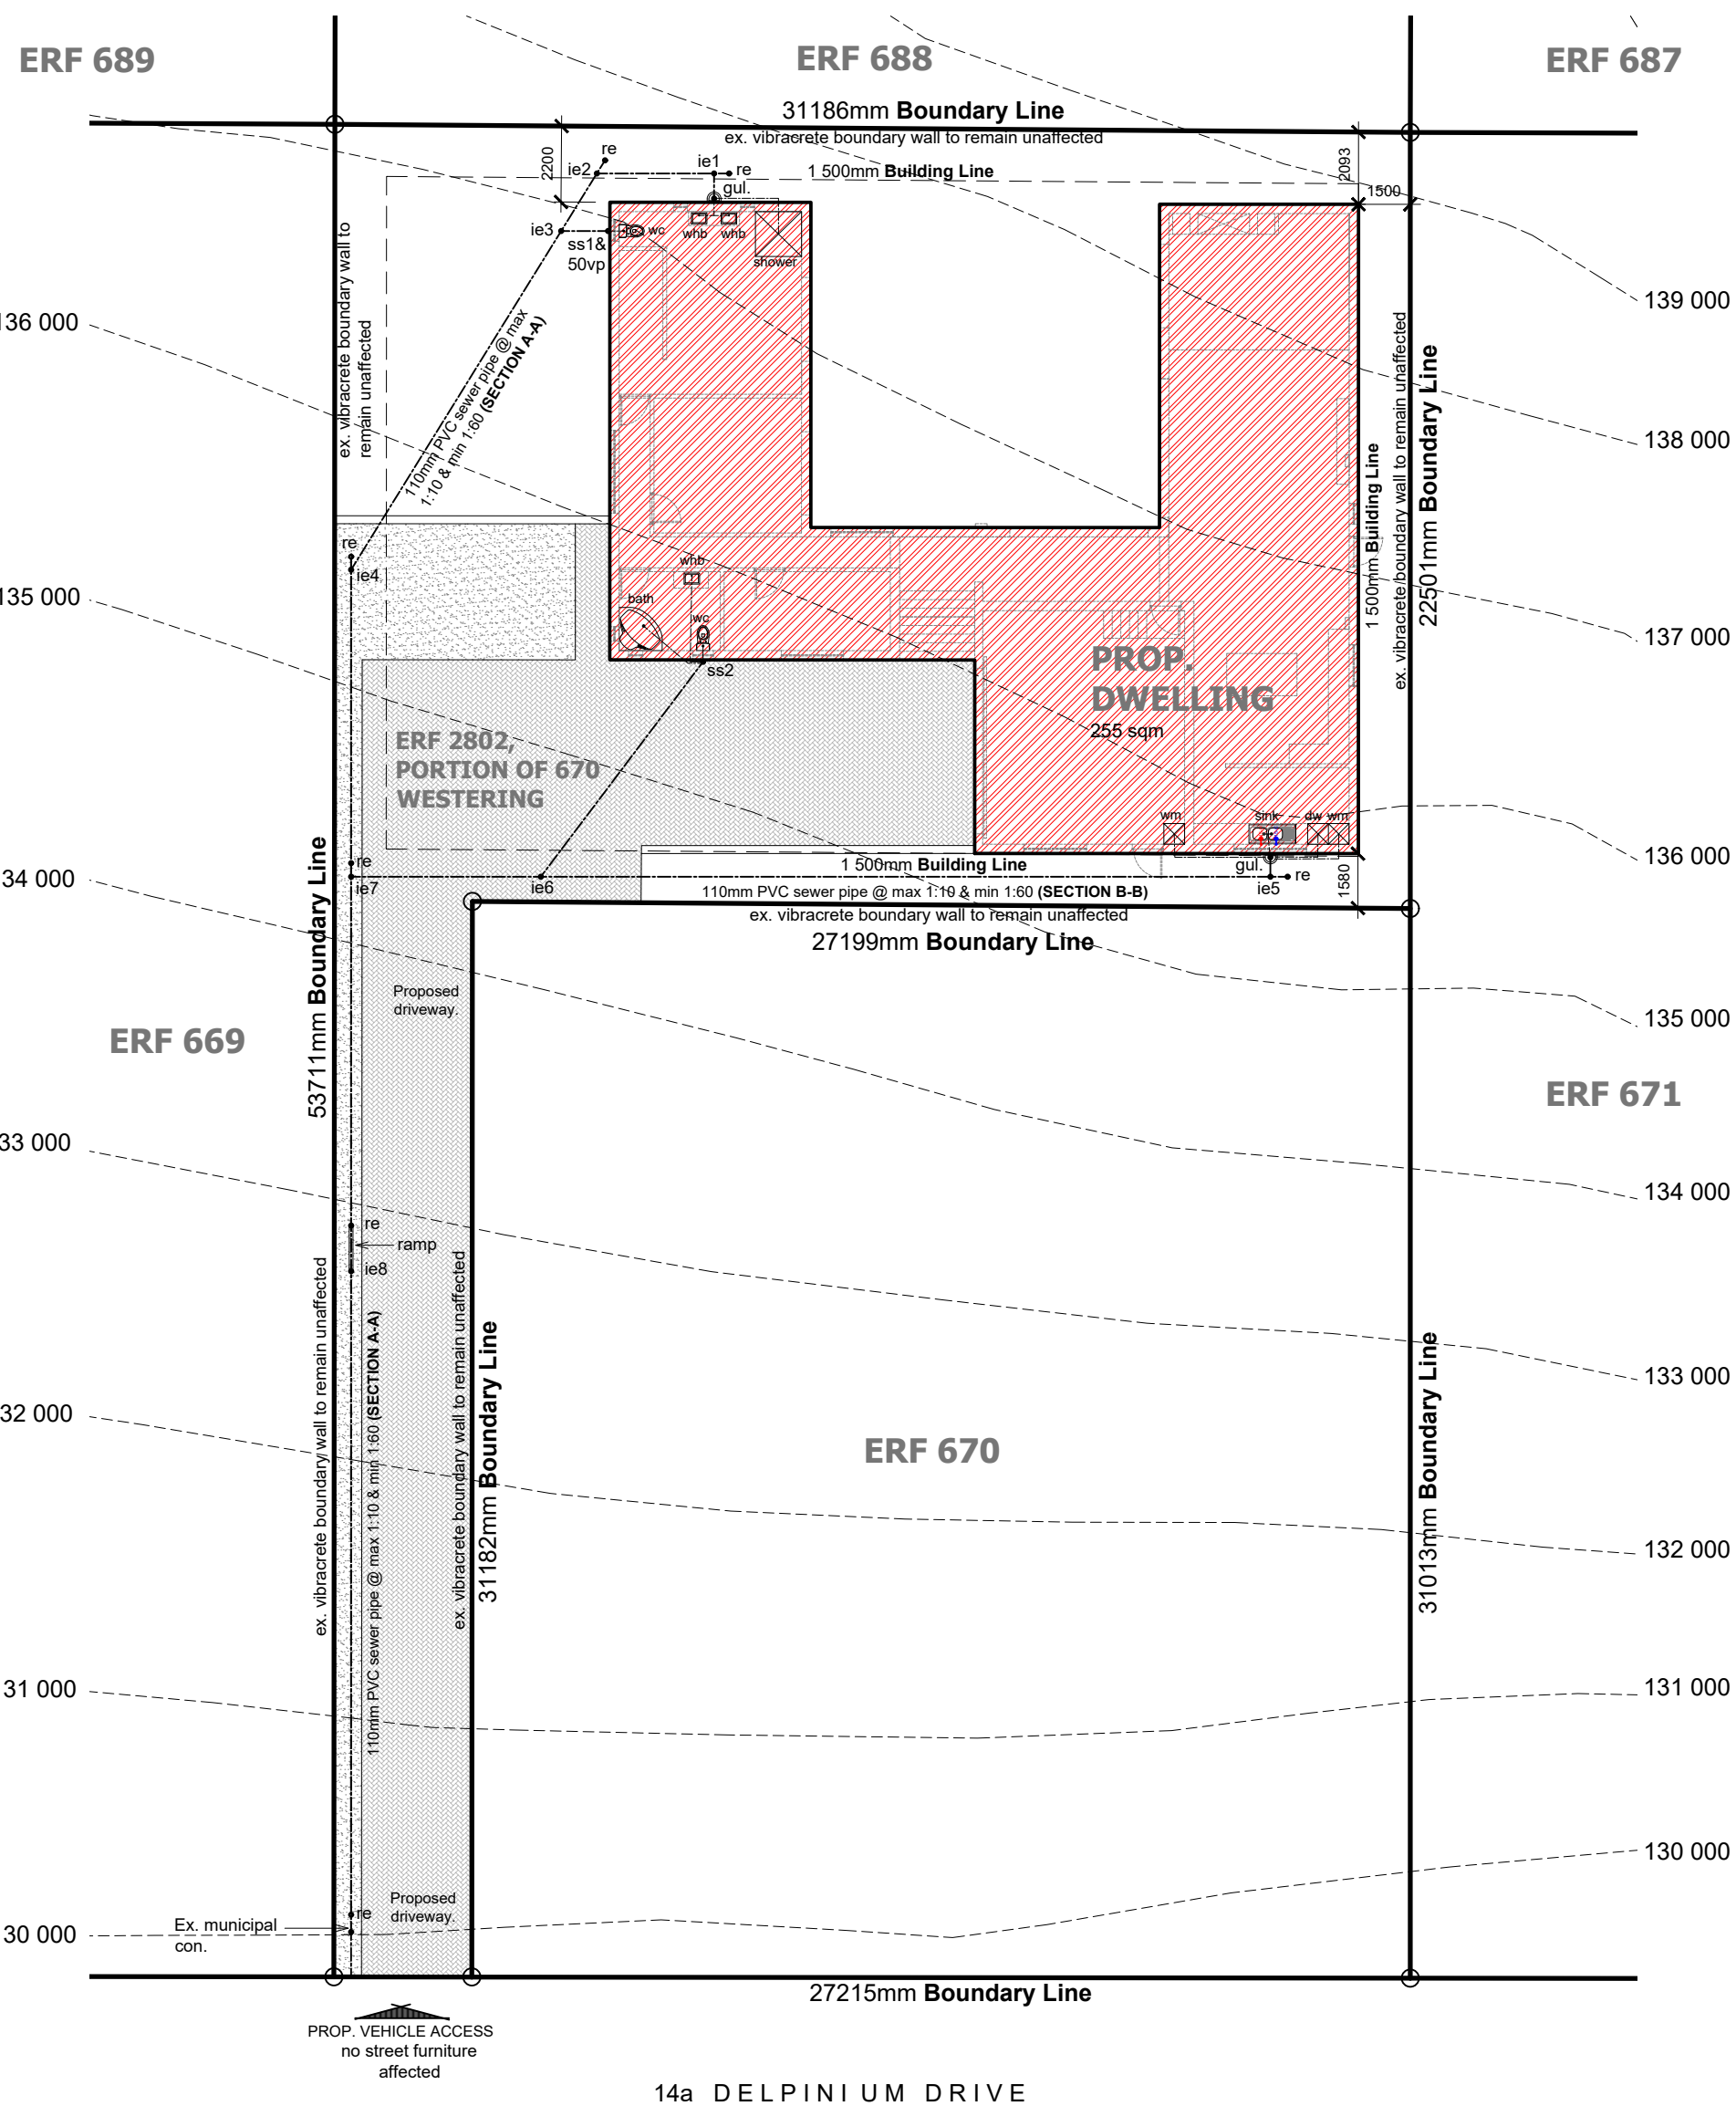
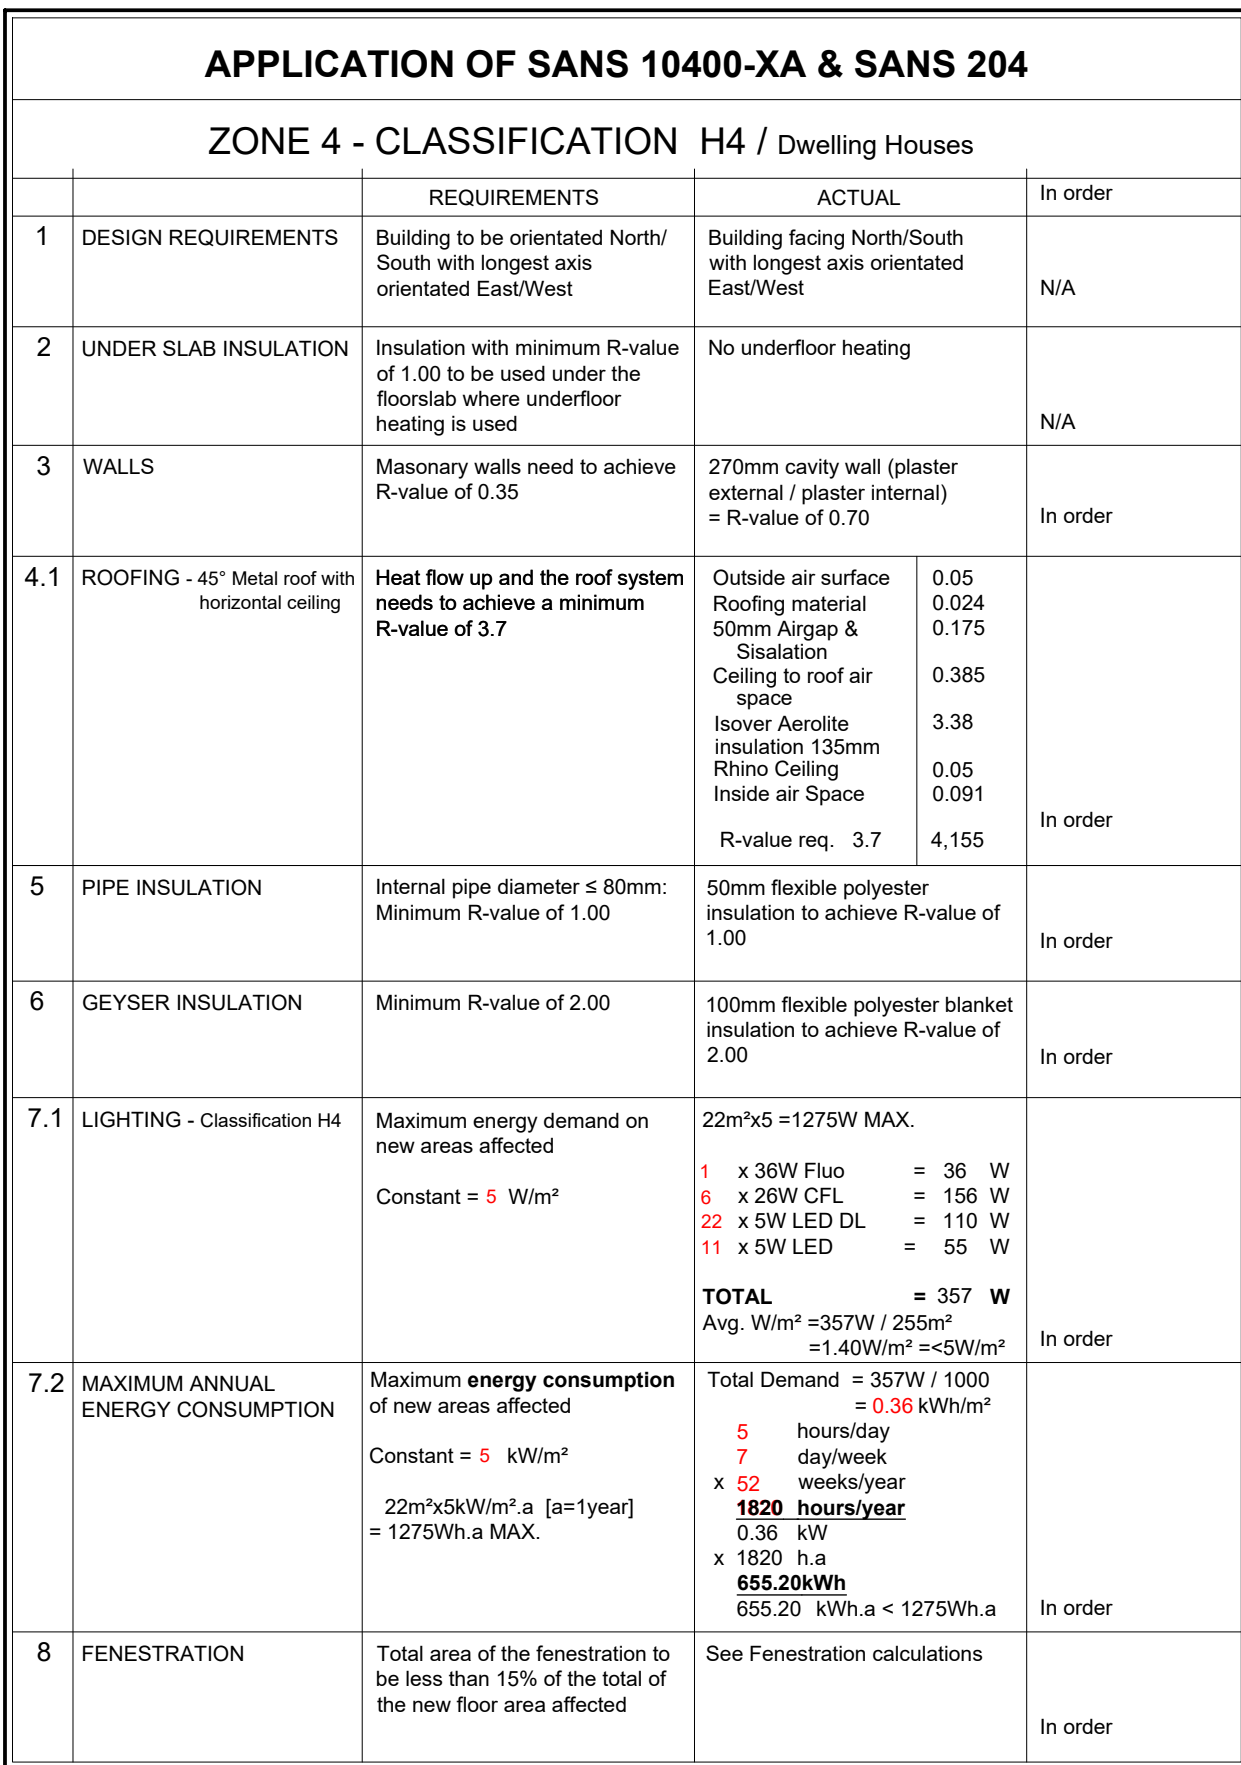
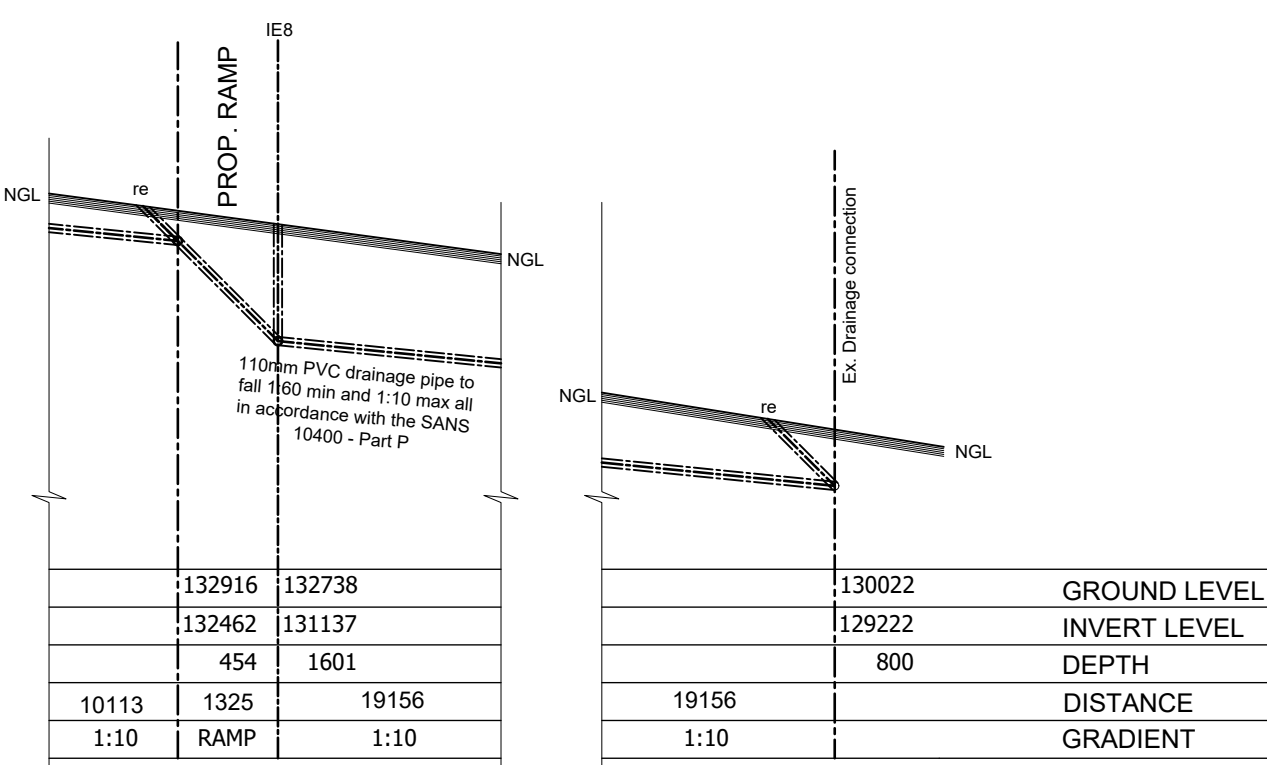
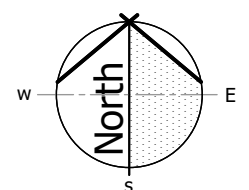


AMENDED PLAN NO.: 350597

PENETRATIONS SCHEDULE													
TAG	WIDTH	HEIGHT	FRAME-GLAZING	OVERHANG	U-VALUE	SHGC	O	P/H	A	C	LU P/H	E	AXSXE
D1/1	2179	2150	HINGED W/D: 6.38mm Clear (Single)	2155	5.93	0.57	South-East	0.81	4.68	27.75	0.80	0.38	1.01
D3/1	2432	2150	HINGED W/D: 6.38mm Clear (Single)	535	5.93	0.57	North-East	0.20	5.23	31.01	0.20	0.77	2.30
D4/1	2411	2150	HINGED W/D: 6.38mm Clear (Single)	535	5.93	0.57	North-East	0.20	5.18	30.72	0.20	0.77	2.27
D5/1	4010	2150	HINGED W/D: 6.38mm Clear (Single)	535	5.93	0.57	North-West	0.20	8.62	51.12	0.20	0.91	4.47
D6/1	4019	2150	HINGED W/D: 6.38mm Clear (Single)	535	5.93	0.57	South-West	0.20	8.64	51.24	0.20	0.82	4.04
D7/1	2416	2150	HINGED W/D: 6.38mm Clear (Single)	535	5.93	0.57	South-West	0.20	5.19	30.78	0.20	0.82	2.43
W1/1	1806	1200	HINGED W/D: 6.38mm Clear (Single)	335	5.93	0.57	South-East	0.20	2.17	12.87	0.20	0.65	0.80
W2/1	600	900	HINGED W/D: 6.38mm Clear (Single)	335	5.93	0.57	South-East	0.24	0.54	3.20	0.20	0.65	0.20
W2/2	600	900	HINGED W/D: 6.38mm Clear (Single)	335	5.93	0.57	South-West	0.38	0.54	3.20	0.35	0.71	0.22
W3/1	420	1500	HINGED W/D: 6.38mm Clear (Single)	335	5.93	0.57	South-East	0.17	0.63	3.74	0.15	0.69	0.25
W3/2	420	1500	HINGED W/D: 6.38mm Clear (Single)	335	5.93	0.57	South-West	0.27	0.63	3.74	0.25	0.78	0.28
W4/1	2400	340	HINGED W/D: 6.38mm Clear (Single)	535	5.93	0.57	South-West	0.64	0.82	4.86	0.60	0.58	0.27
W5/1	402	1800	HINGED W/D: 6.38mm Clear (Single)	335	5.93	0.57	North-West	0.15	0.72	4.27	0.15	0.97	0.40
W5/2	402	1800	HINGED W/D: 6.38mm Clear (Single)	335	5.93	0.57	North-West	0.15	0.72	4.27	0.15	0.97	0.40
W6/1	1520	1200	HINGED W/D: 6.38mm Clear (Single)	535	5.93	0.57	North-West	0.31	1.82	10.79	0.30	0.8	0.83
W7/1	610	1800	HINGED W/D: 6.38mm Clear (Single)	535	5.93	0.57	North-East	0.23	1.10	6.52	0.20	0.77	0.48
W7/2	610	1800	HINGED W/D: 6.38mm Clear (Single)	535	5.93	0.57	North-East	0.23	1.10	6.52	0.20	0.77	0.48
W8/1	1200	900	HINGED W/D: 6.38mm Clear (Single)	535	5.93	0.57	North-East	0.38	1.08	6.40	0.35	0.63	0.39
W9/1	2100	900	HINGED W/D: 6.38mm Clear (Single)	335	5.93	0.57	South-East	0.24	1.89	11.21	0.20	0.65	0.70
SUMMARY													
ZONE	Cu	CHSG	NETT FLOOR AREA	TOTAL GLAZING AREA	GLAZING %	CONDUCTANCE	SHGC						
					15	356.76	33.13						
					20.13	304.21	22.22						
4	1.4	0.13	254.83	51.30	CALCULATE	COMPLY	COMPLY						

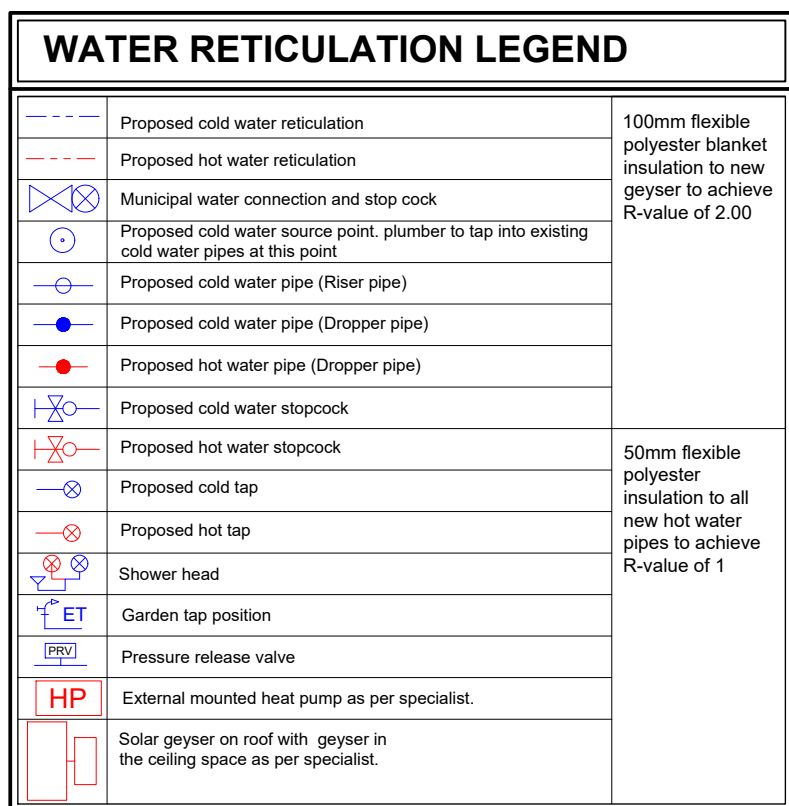

ELECTRICAL LEGEND					
	LED Down lighter as per client specification		Shavers plug		Intercom system.
	Single wall mounted light switch to be mounted at 1300mm above sill		Telpoint point		Intercom
	Double wall mounted light switch to be mounted at 1300mm above sill		Network point		Alarm
	Triple wall mounted light switch to be mounted at 1300mm above sill		Oven Indicator		Alarm Pad
	2-way wall mounted light switch to be mounted at 1300mm above sill		2 x 1W 1500 Long 7 tube fluorescent armature with prismatic diffuser suspended from ceiling		Hair dryer waterproof plug
	Dimmer wall mounted light switch to be mounted at 1300mm above sill		5 Watt LED Down lighter as per specification		Main distribution board
	Water tight wall mounted light switch to be mounted at 1300mm above sill		20 Watt Compact Fluorescent pendant light as per specification		Sub distribution board
	Double wall mounted plug, top of socket to be 107mm above sill		10 Watt x 2 Internal LED Wall mounted light		Garage door ceiling mounted motor & plug
	Triple wall mounted plug, top of socket to be 300mm above sill		10 Watt x 2 External LED Wall mounted light		Blank consulting boxes
	Water tight double wall mounted plug, top of socket to be 300mm above sill		50 Watt External LED Wall mounted spotlight		
	Extractor connection plug @ 2100mm		Pre-paid Electricity meter		
	TV point aerial		Daylight sensor		

REVISIONS:

GENERAL NOTES:

[illegible]

DRAWING TITLE:

MUNICIPAL SUBMISSIONS

PROJECT TITLE:

PROPOSED NEW DWELLING ON ERF
2802, PORTION OF 670, WESTERING
PORT ELIZABETH FOR MR VAN
LOGGENBERG

.....
CLIENT SIGNATURE



072 799 9597
hgouws.renders@gmail.com

01 Elsa Joubert Street
Fairview
Port Elizabeth, 6075

23 Feb 22

.....

PROFESSIONAL SIGNATURE

MUNICIPAL INFORMATION:

ERF NO:	2802, PORTION OF 670, Western
ERF AREA:	845 sqm
EXISTING AREA:	0 sqm
NEW AREA:	255 sqm
TOTAL AREA:	255 sqm
EX. COVERAGE:	0 sqm 0%
NEW COVERAGE:	255 sqm - 30%
TOTAL COVERAGE:	255 sqm - 30%
NEW GARAGES:	Double
NEW BATHROOMS:	2
POOL:	NO
BOUNDARY WALLS:	0 M
AGE OF BUILDING:	NEW



COPYRIGHT:

This drawing is subject to copyright, and may not be reproduced in whole or part in any matter whatsoever without written permission from H.Gouws Renders.

PROJECT NO.

2022_Charl

DRAWING NO.

20220223_0

DRAWN BY:
UC

REVISION NO.:

00

00

SHEET NO.:

10

101