


ELECTRICAL LEGEND

- | | |
|---|--|
|  | LED Downlight lighter as per client specification |
|  | Single wall mounted light switch to be mounted at 1300mm above uffi. |
|  | Double wall mounted light switch to be mounted at 1300mm above uffi. |
|  | Triple wall mounted light switch to be mounted at 1300mm above uffi. |
|  | 5-way wall mounted light switch to be mounted at 1300mm above uffi. |
|  | Waterfall wall mounted light switch to be mounted at 1300mm above uffi. |
|  | Dimmer wall mounted light switch to be mounted at 1300mm above uffi. |
|  | Double wall mounted light switch, top of socket to be 1250mm above uffi. |
|  | Double wall mounted plug, top of socket to be 300mm above uffi. |
|  | Double wall mounted waterfall plug |
|  | Extractor connection plug @ 2100mm |
|  | Blank conduiting boxes |
|  | Periscope plug as per specification. |
|  | Garage door ceiling mounted motor |
|  | IV point aerial |
|  | Shaver plug |
|  | Telkom point |
|  | Network point |
|  | Power isolator |
|  | Stove Skirting |
|  | (2 x 18 W) 1500 Long 2 tube fluorescent armature with prismatic aerial suspended from ceiling. |
|  | 5 Watt LED Down lighter as per specification |
|  | 20 Watt Compact Fluorescent pendant light as per specification |
|  | (10 Watt x 2) Internal LED Wall mounted light |
|  | (10 Watt x 2) External LED Wall mounted light |
|  | 10 Watt External LED Wall mounted spotlight |
|  | 15 Watt Internal compact Fluorescent Up Lighter (wall mounted) as per client |
|  | Starlights (wall mounted) as per client |
|  | LED Strip Lighting |
|  | Pool light as per client |
|  | Foot light |
|  | Bectical fence control box. |
|  | Gate Control Unit |
|  | Pre-paid Electricity meter |
|  | Daylight sensor |
|  | Intercom |
|  | Intercom system. |
|  | Alarm |
|  | Hair dryer waterproof plug |
|  | Main distribution board |
|  | Sub distribution board |
|  | Uninterruptible power supply |
|  | Sieve to be installed for future fibre optic installations, sieve to be as per specialist. |

WATER RETICULATION LEGEND

- | | | |
|---|---|--|
|  | proposed cold water source point, plumber to tap into existing cold water pipes at this point | 95mm flexible polyester blanket insulation to new geyser to achieve R-value of 2.00 |
|  | municipal water connection and stop cock | |
|  | garden tap position | |
|  | proposed cold water reticulation | 50mm flexible polyester insulation to all new cold water pipes to achieve R-value of 1 |
|  | proposed hot water reticulation | |
|  | proposed cold water pipe up | |
|  | proposed cold water pipe down | |
|  | proposed hot water pipe down | |
|  | proposed cold water stopcock | |
|  | proposed hot water stopcock | |
|  | proposed cold tap | |
|  | proposed hot tap | |
|  | shower head | |
|  | external mounted heat pump as per specialist | |
|  | solar geyser on roof with geyser in the ceiling space as per specialist | |

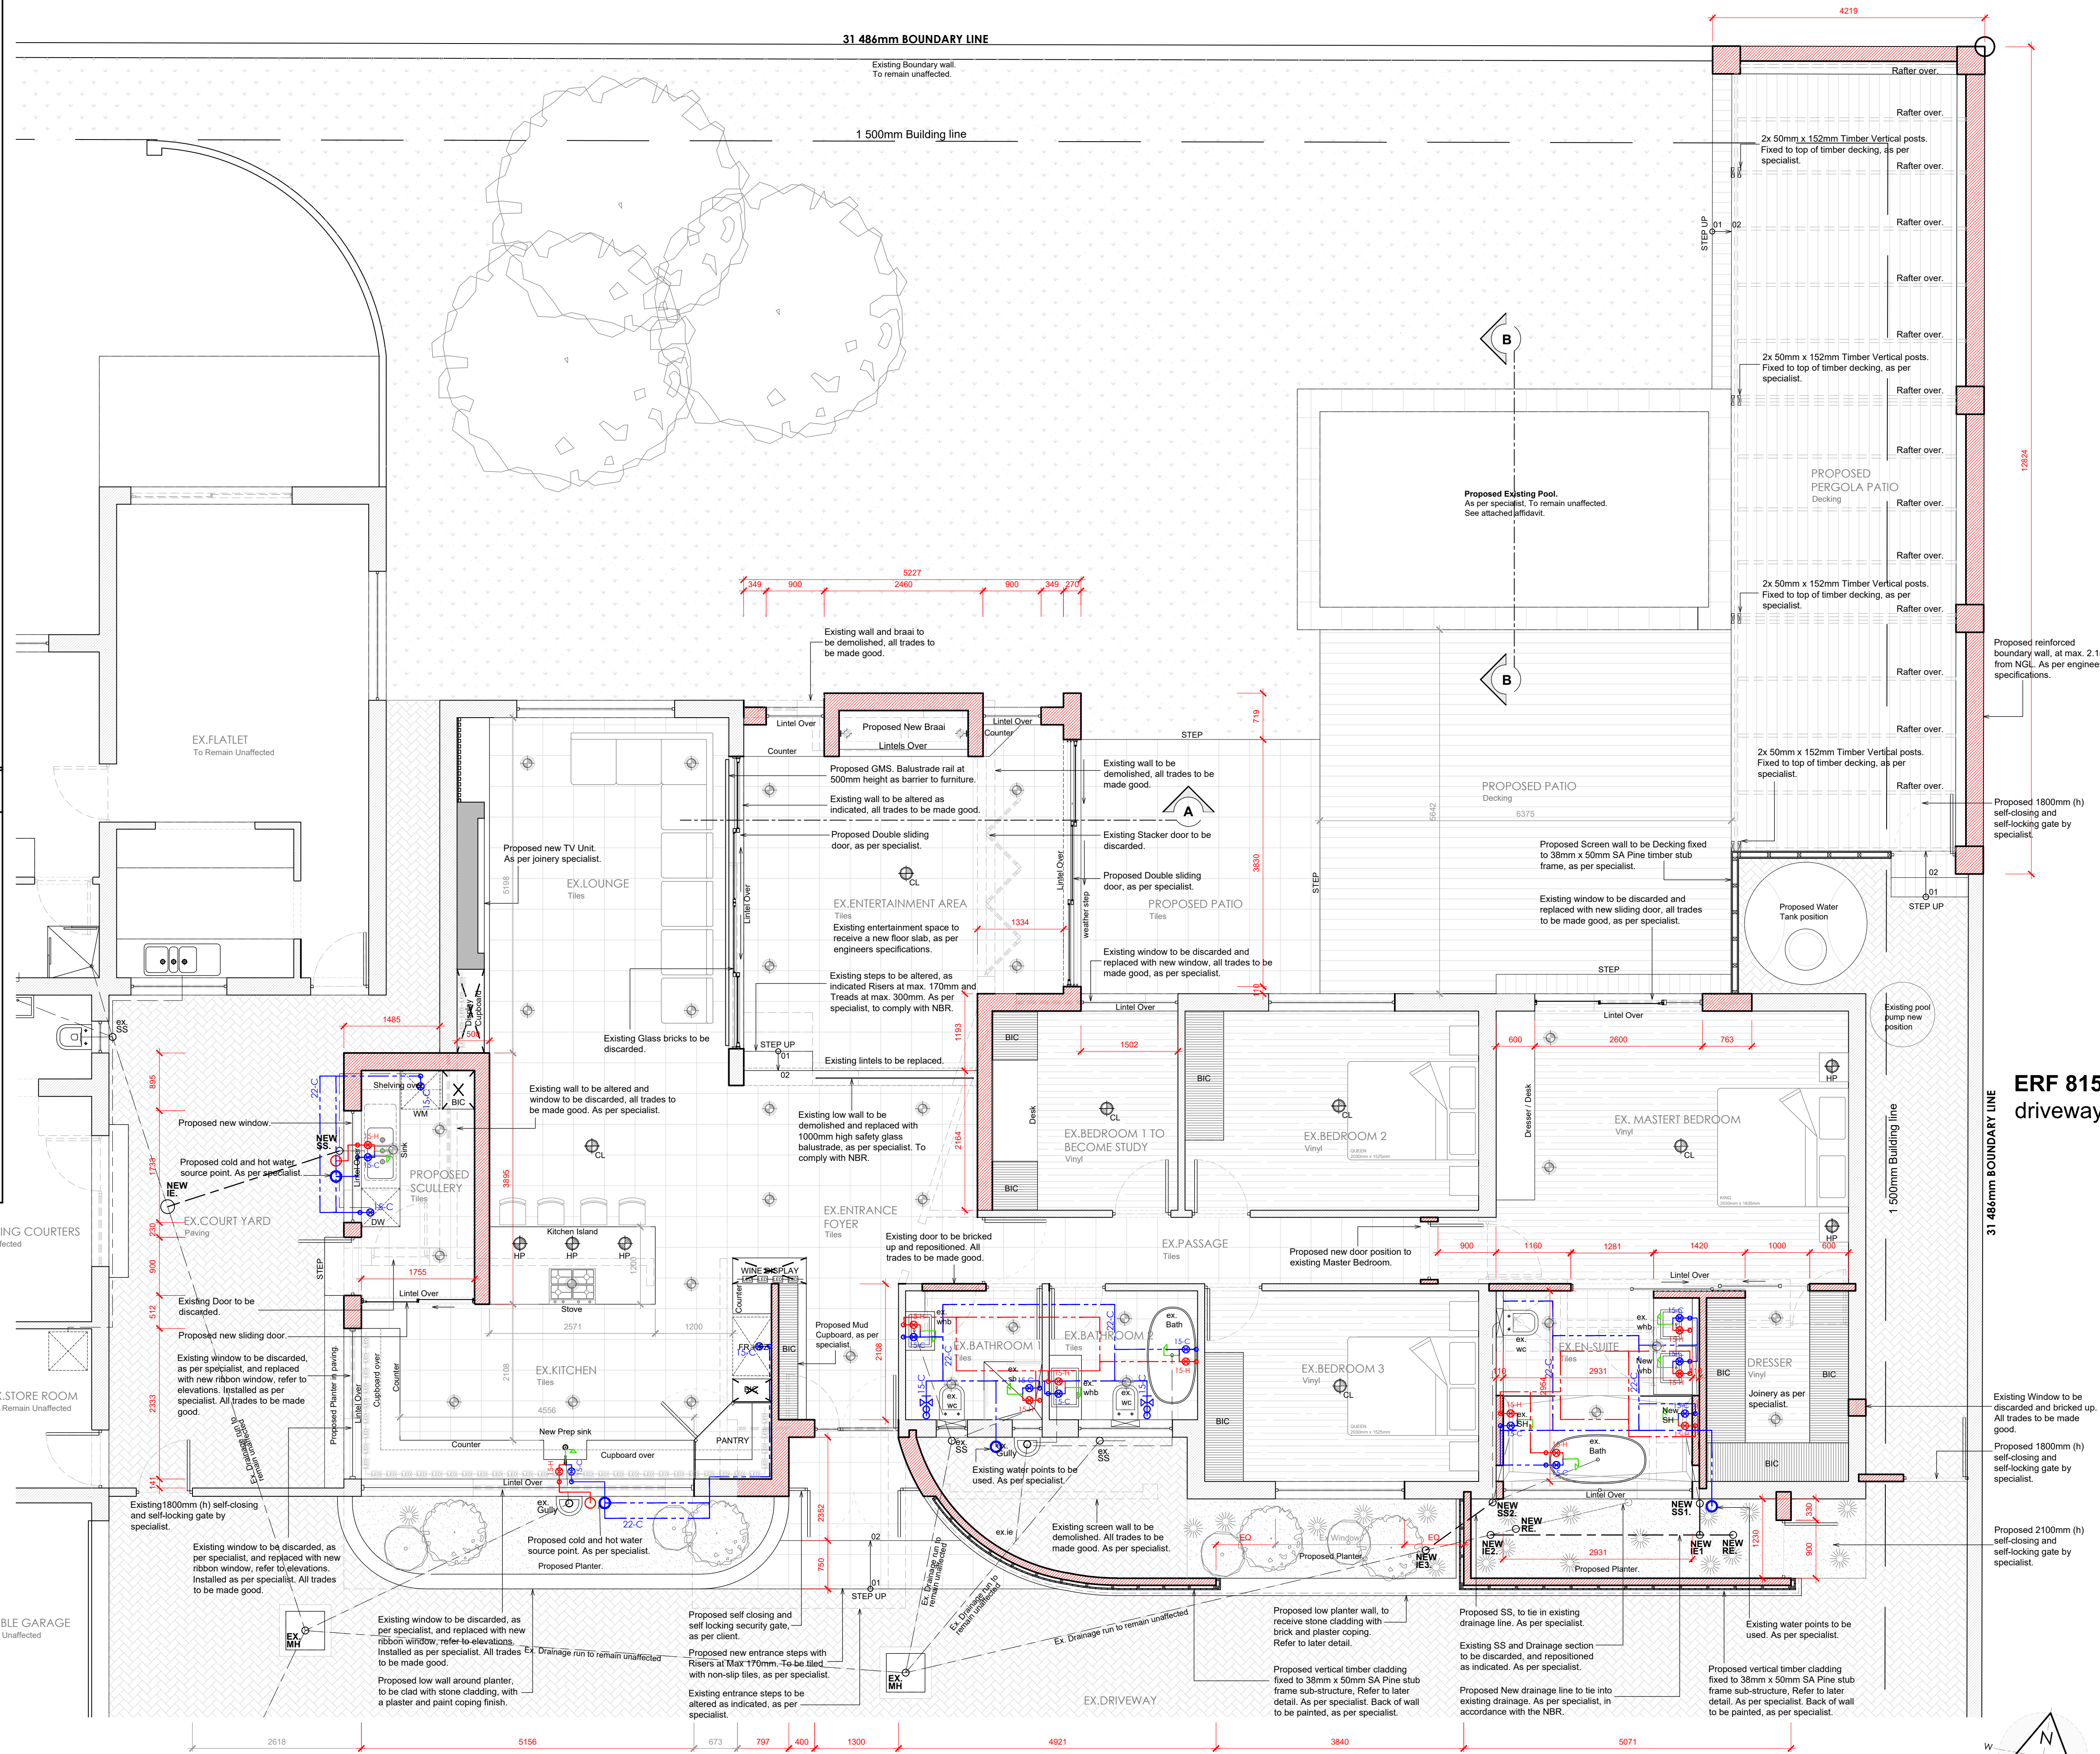

REVISIONS:

[illegible]

GENERAL NOTES:

[illegible]

DRAWING TITLE:

MUNICIPAL SUBMISSION

PROJECT TITLE

ADDITIONS AND ALTERATIONS ON **ERF**
15, SUNRIDGE, PORT ELIZABETH FOR **Mr**
& Mrs Le Roux *pl*


28 Aug 24
 P.P
 CLIENT SIGNATURE



BLACKHOUND
ARCHITECTURE & RENDERING

hannes@blackhoundenterprises.com
072 799 9597 | 072 418 6867

Unit 10, The Network, 19 Cactus Rd
Fairview, Port Elizabeth, 6020

28 Aug 24

PROFESSIONAL SIGNATURE

MUNICIPAL INFORMATION:

ERF NO:	15, SUNRIDGE
ERF AREA:	1299 sqm
EXISTING AREA:	394 sqm
NEW AREA:	13 sqm
TOTAL AREA:	407 sqm
EX. COVERAGE:	394 sqm 30%
NEW COVERAGE:	13 sqm - 1%
TOTAL COVERAGE:	407 sqm - 31%
NEW GARAGES:	0
NEW BATHROOMS:	0
POOL:	NO
BOUNDARY WALLS:	0 M
AGE OF BUILDING:	<60



COPYRIGHT:

This drawing is subject to copyright, and may not be reproduced in whole or part in any matter whatsoever without written permission from Blackhound Architecture & Rendering.

PROJECT NO.:

2024_LeRoux

DRAWING
2024082

DRAWN BY

HG

PRINT DATE: 00.1.2004

REVISION NO.:

00

SHEET NO.:

101