
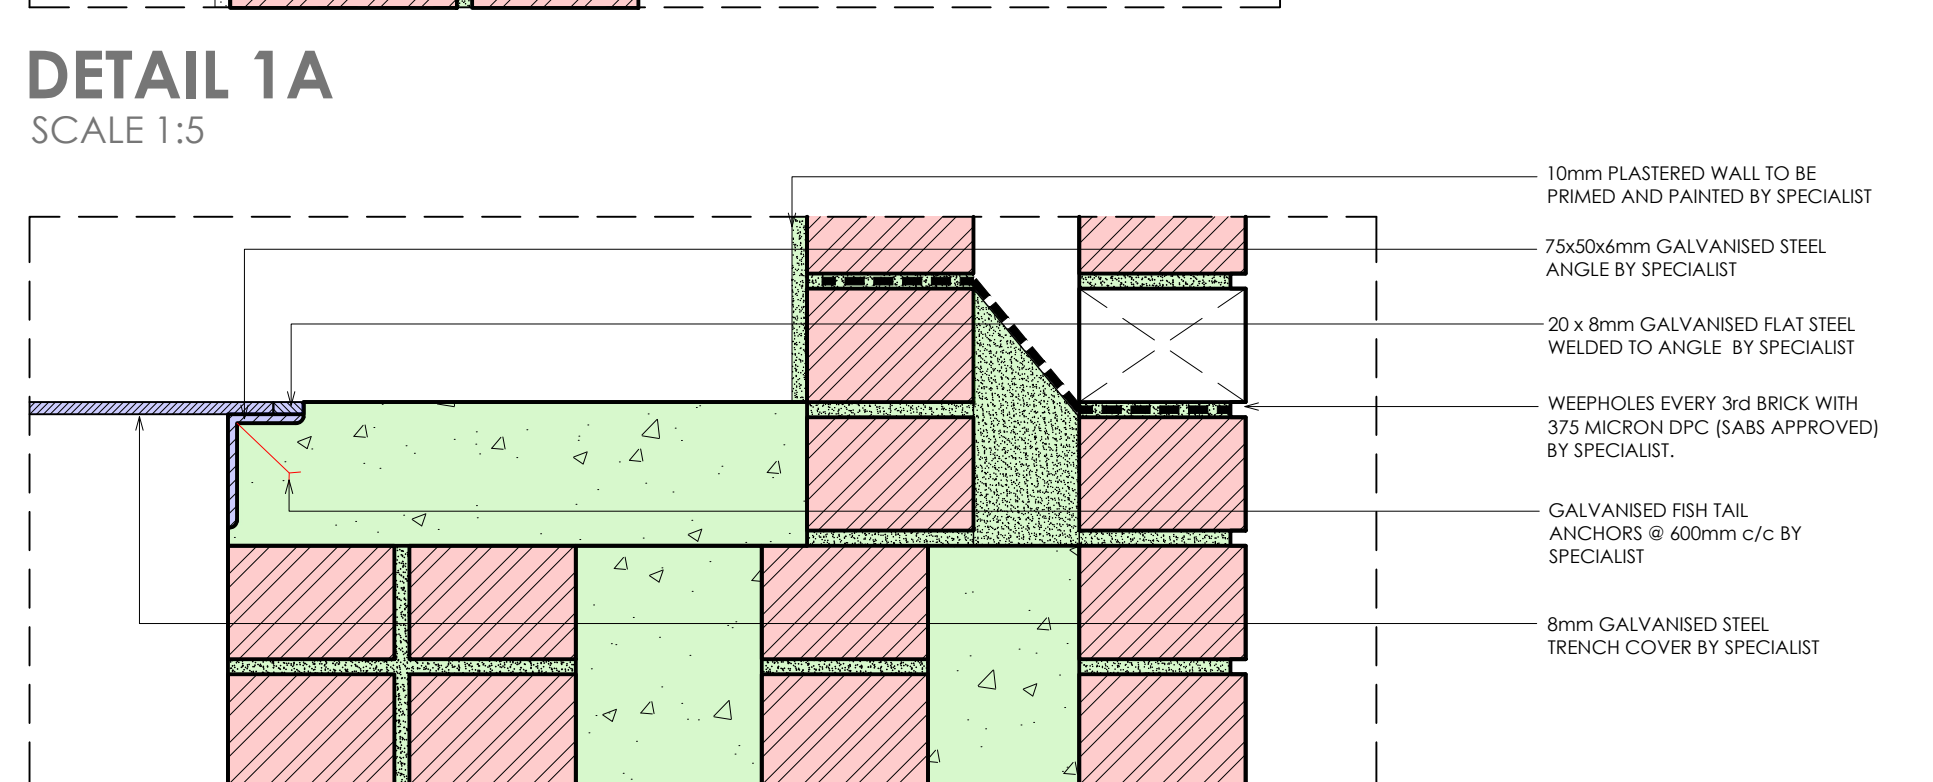
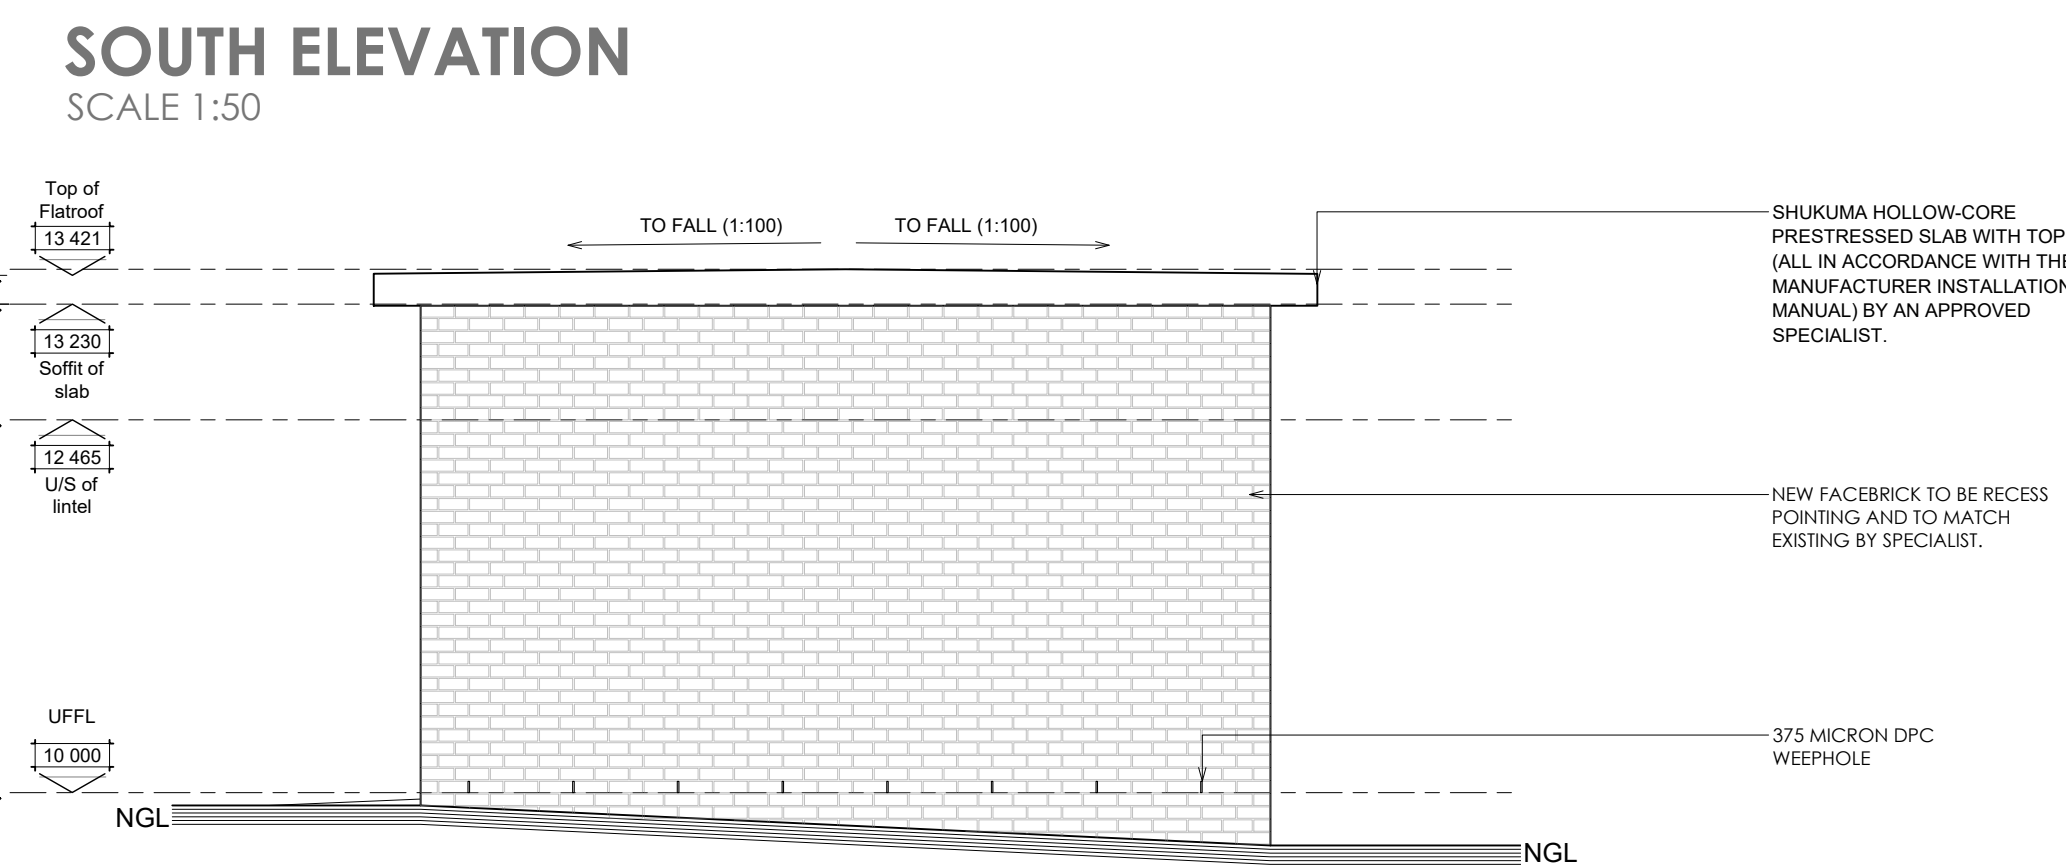
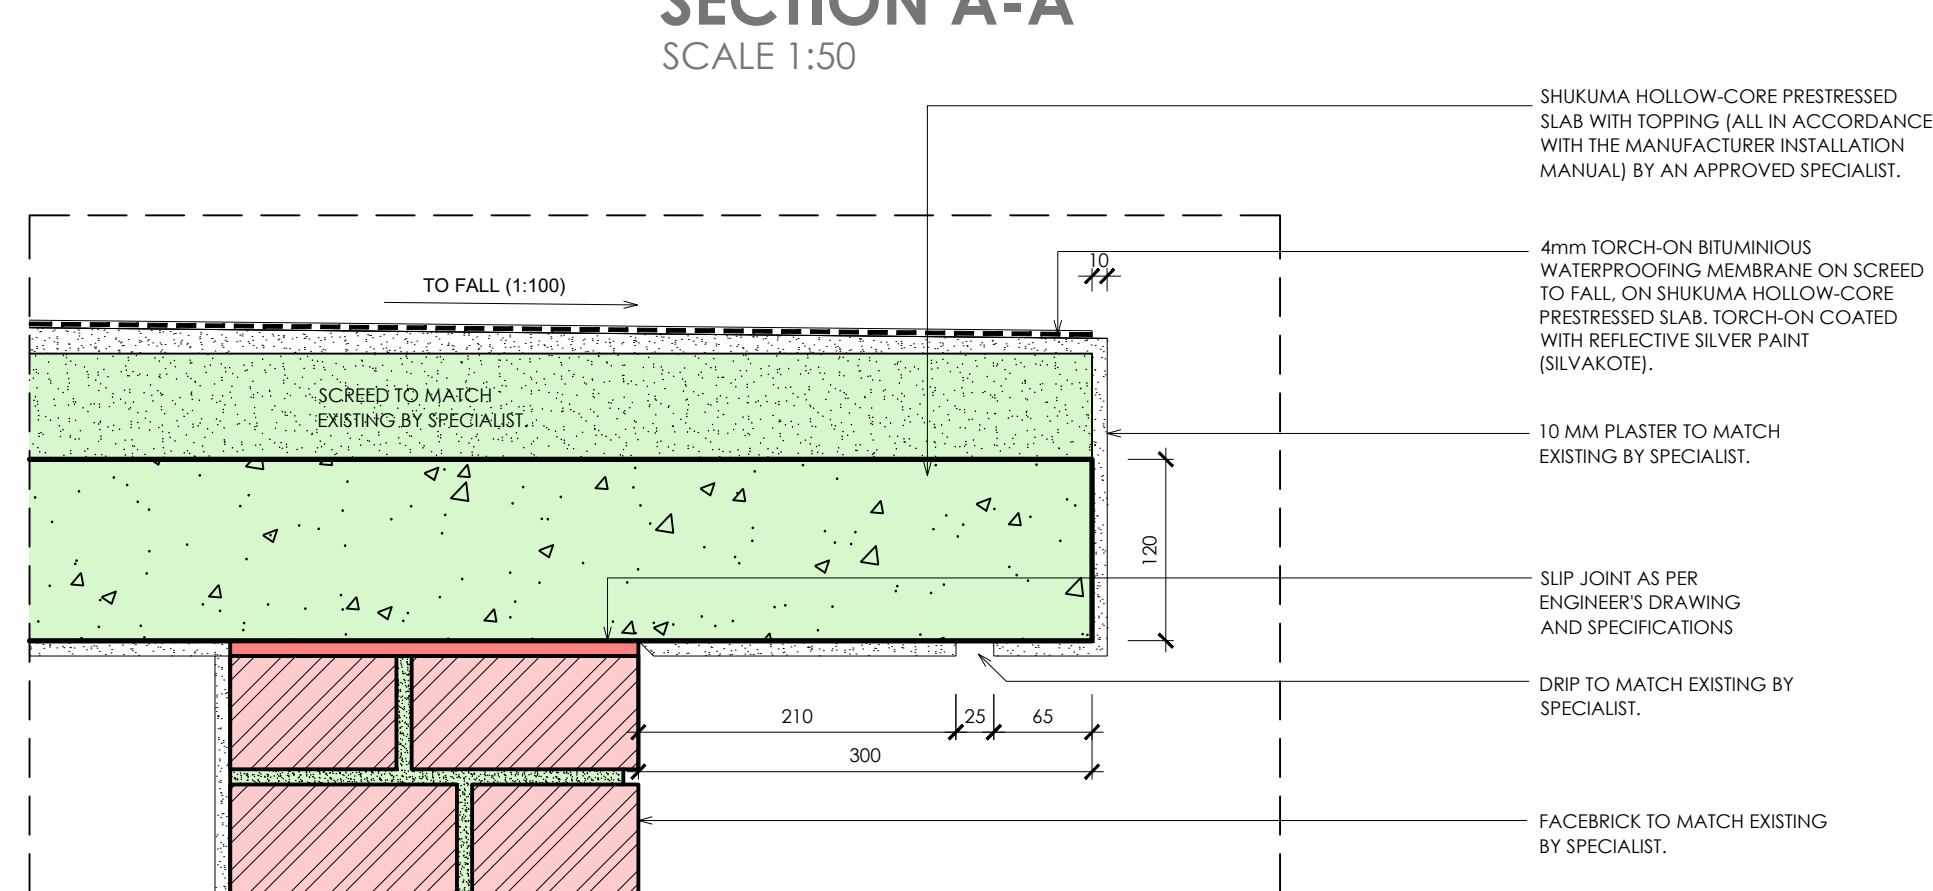
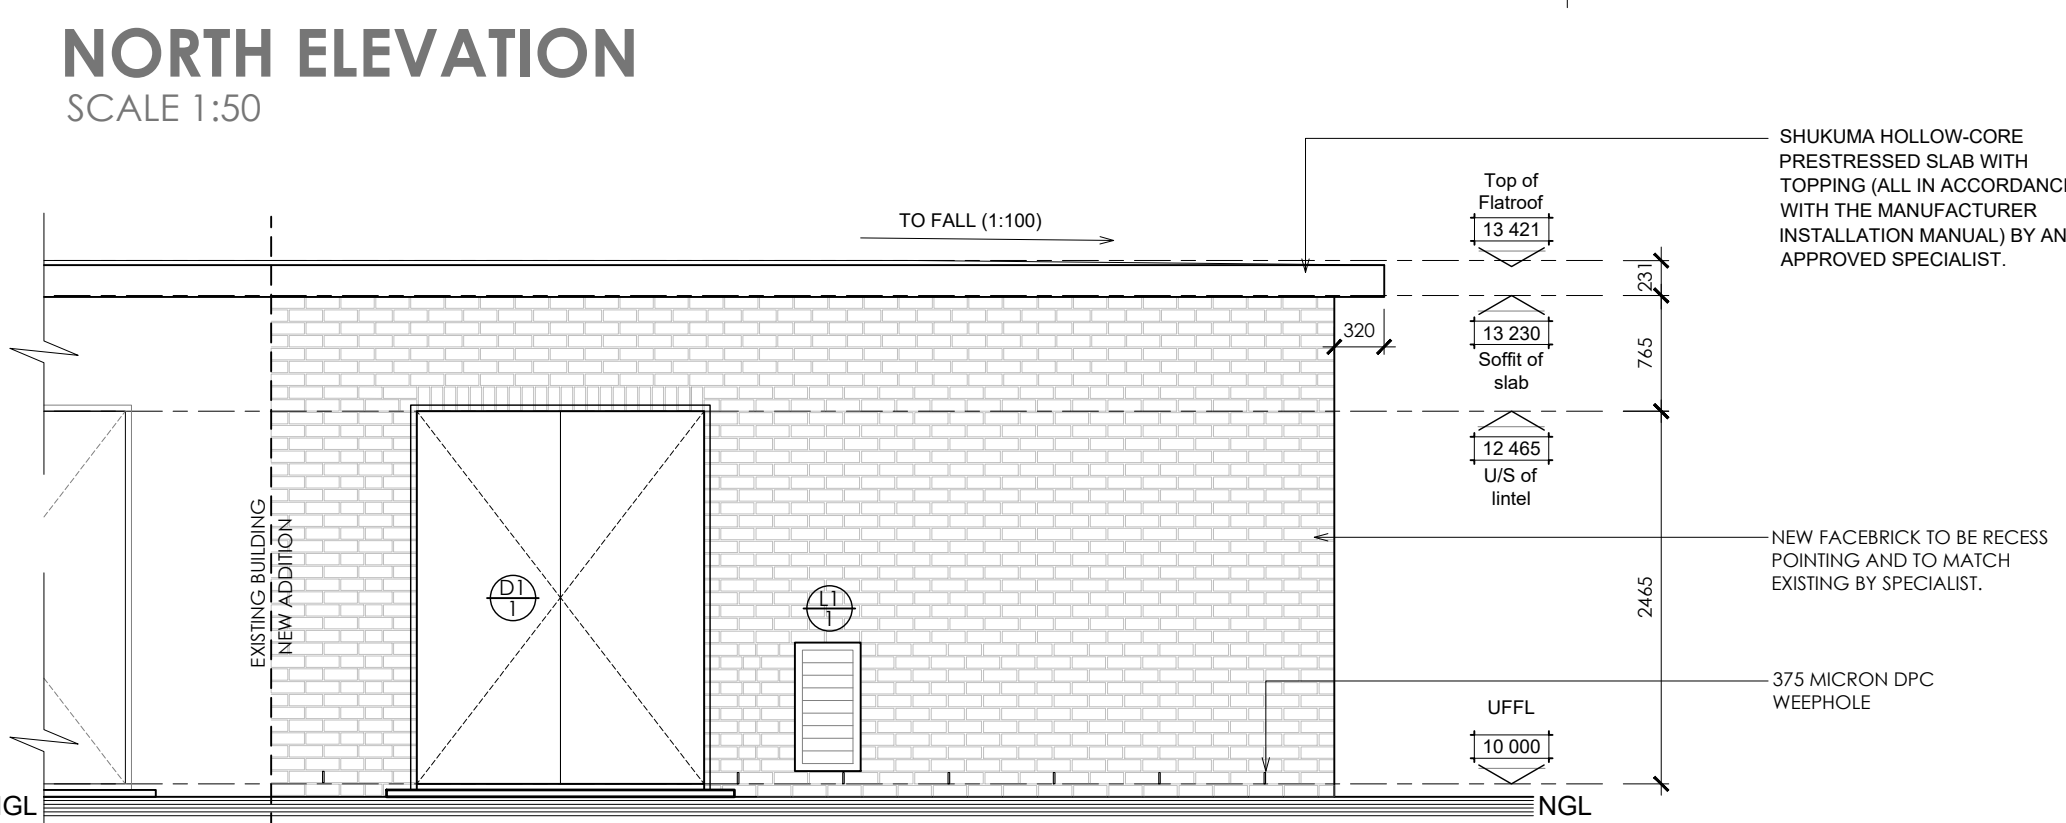
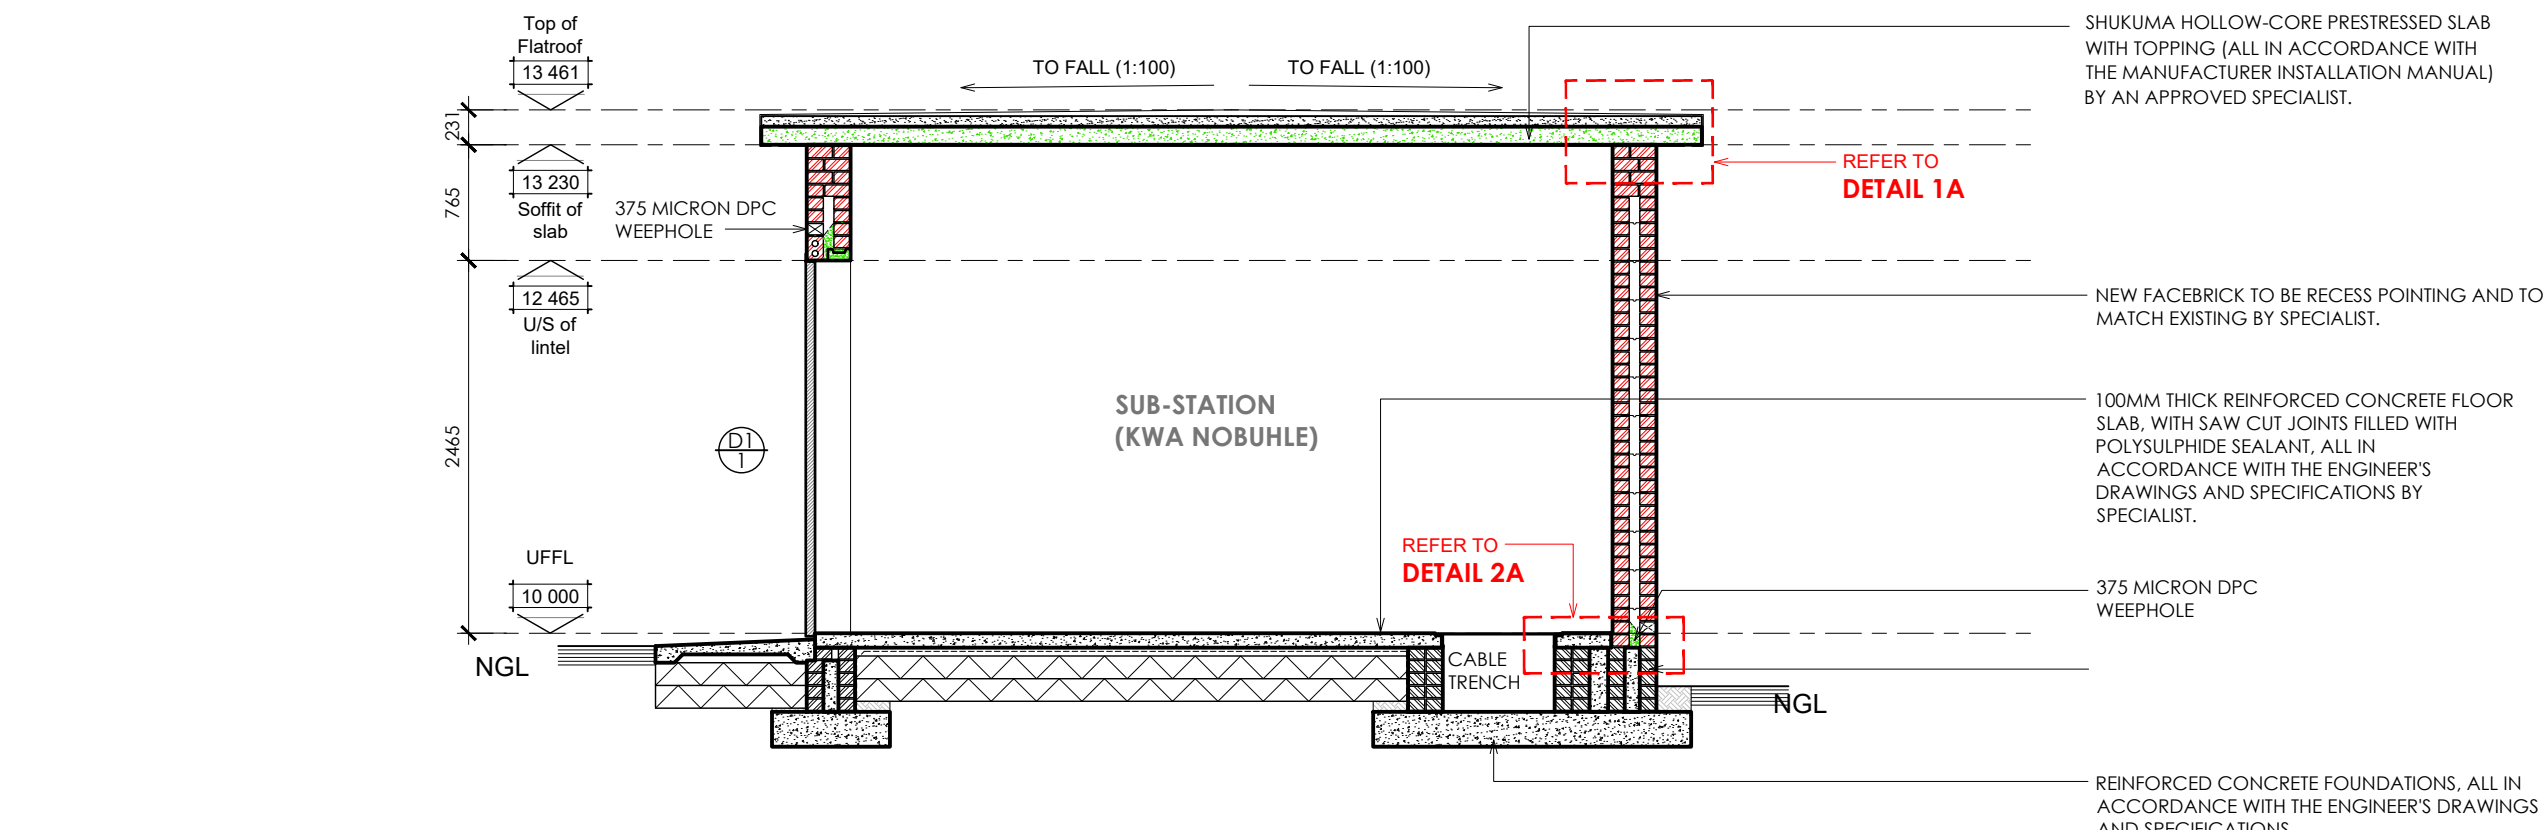
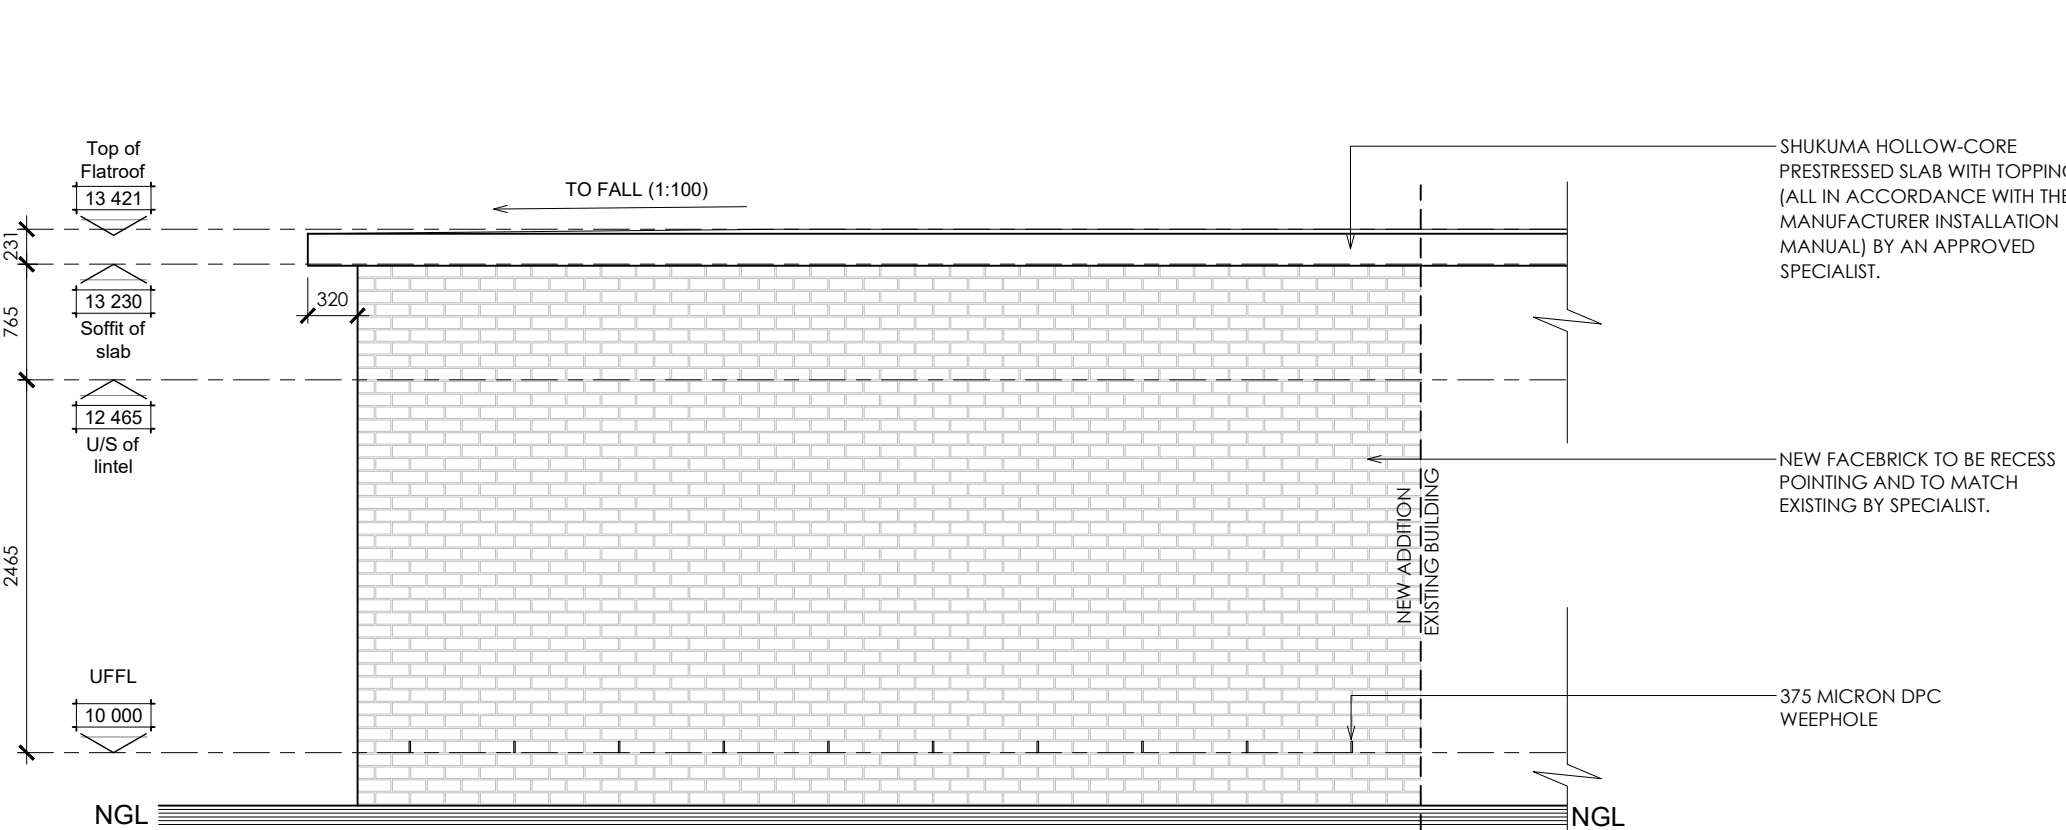
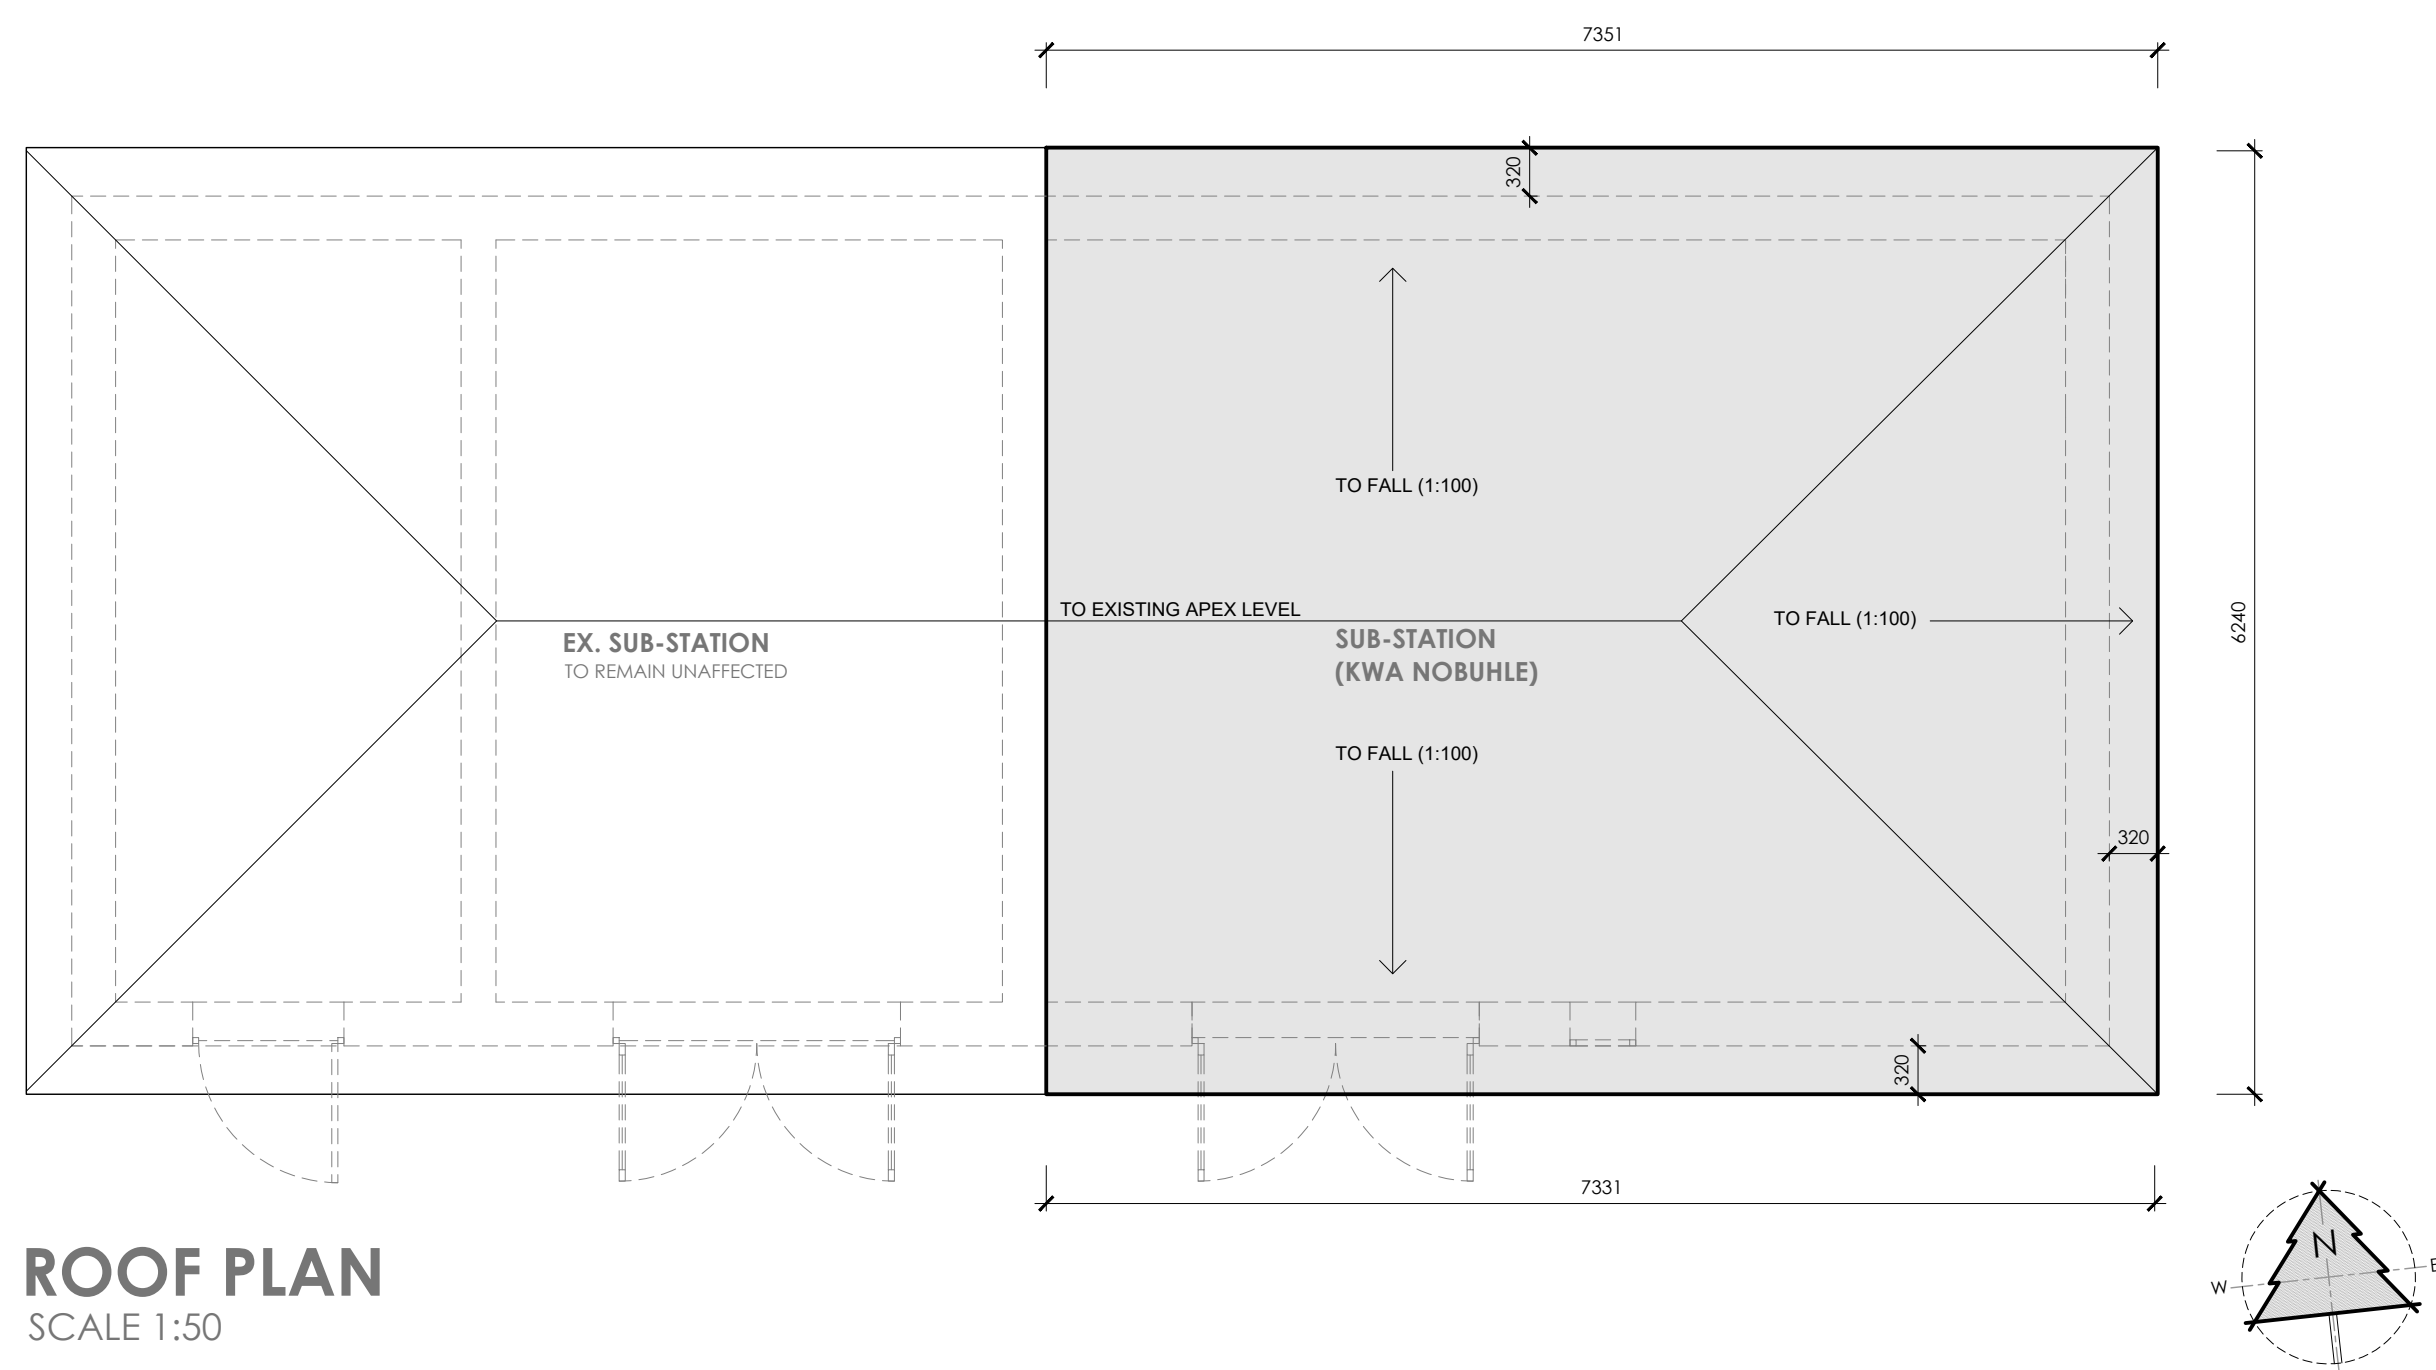


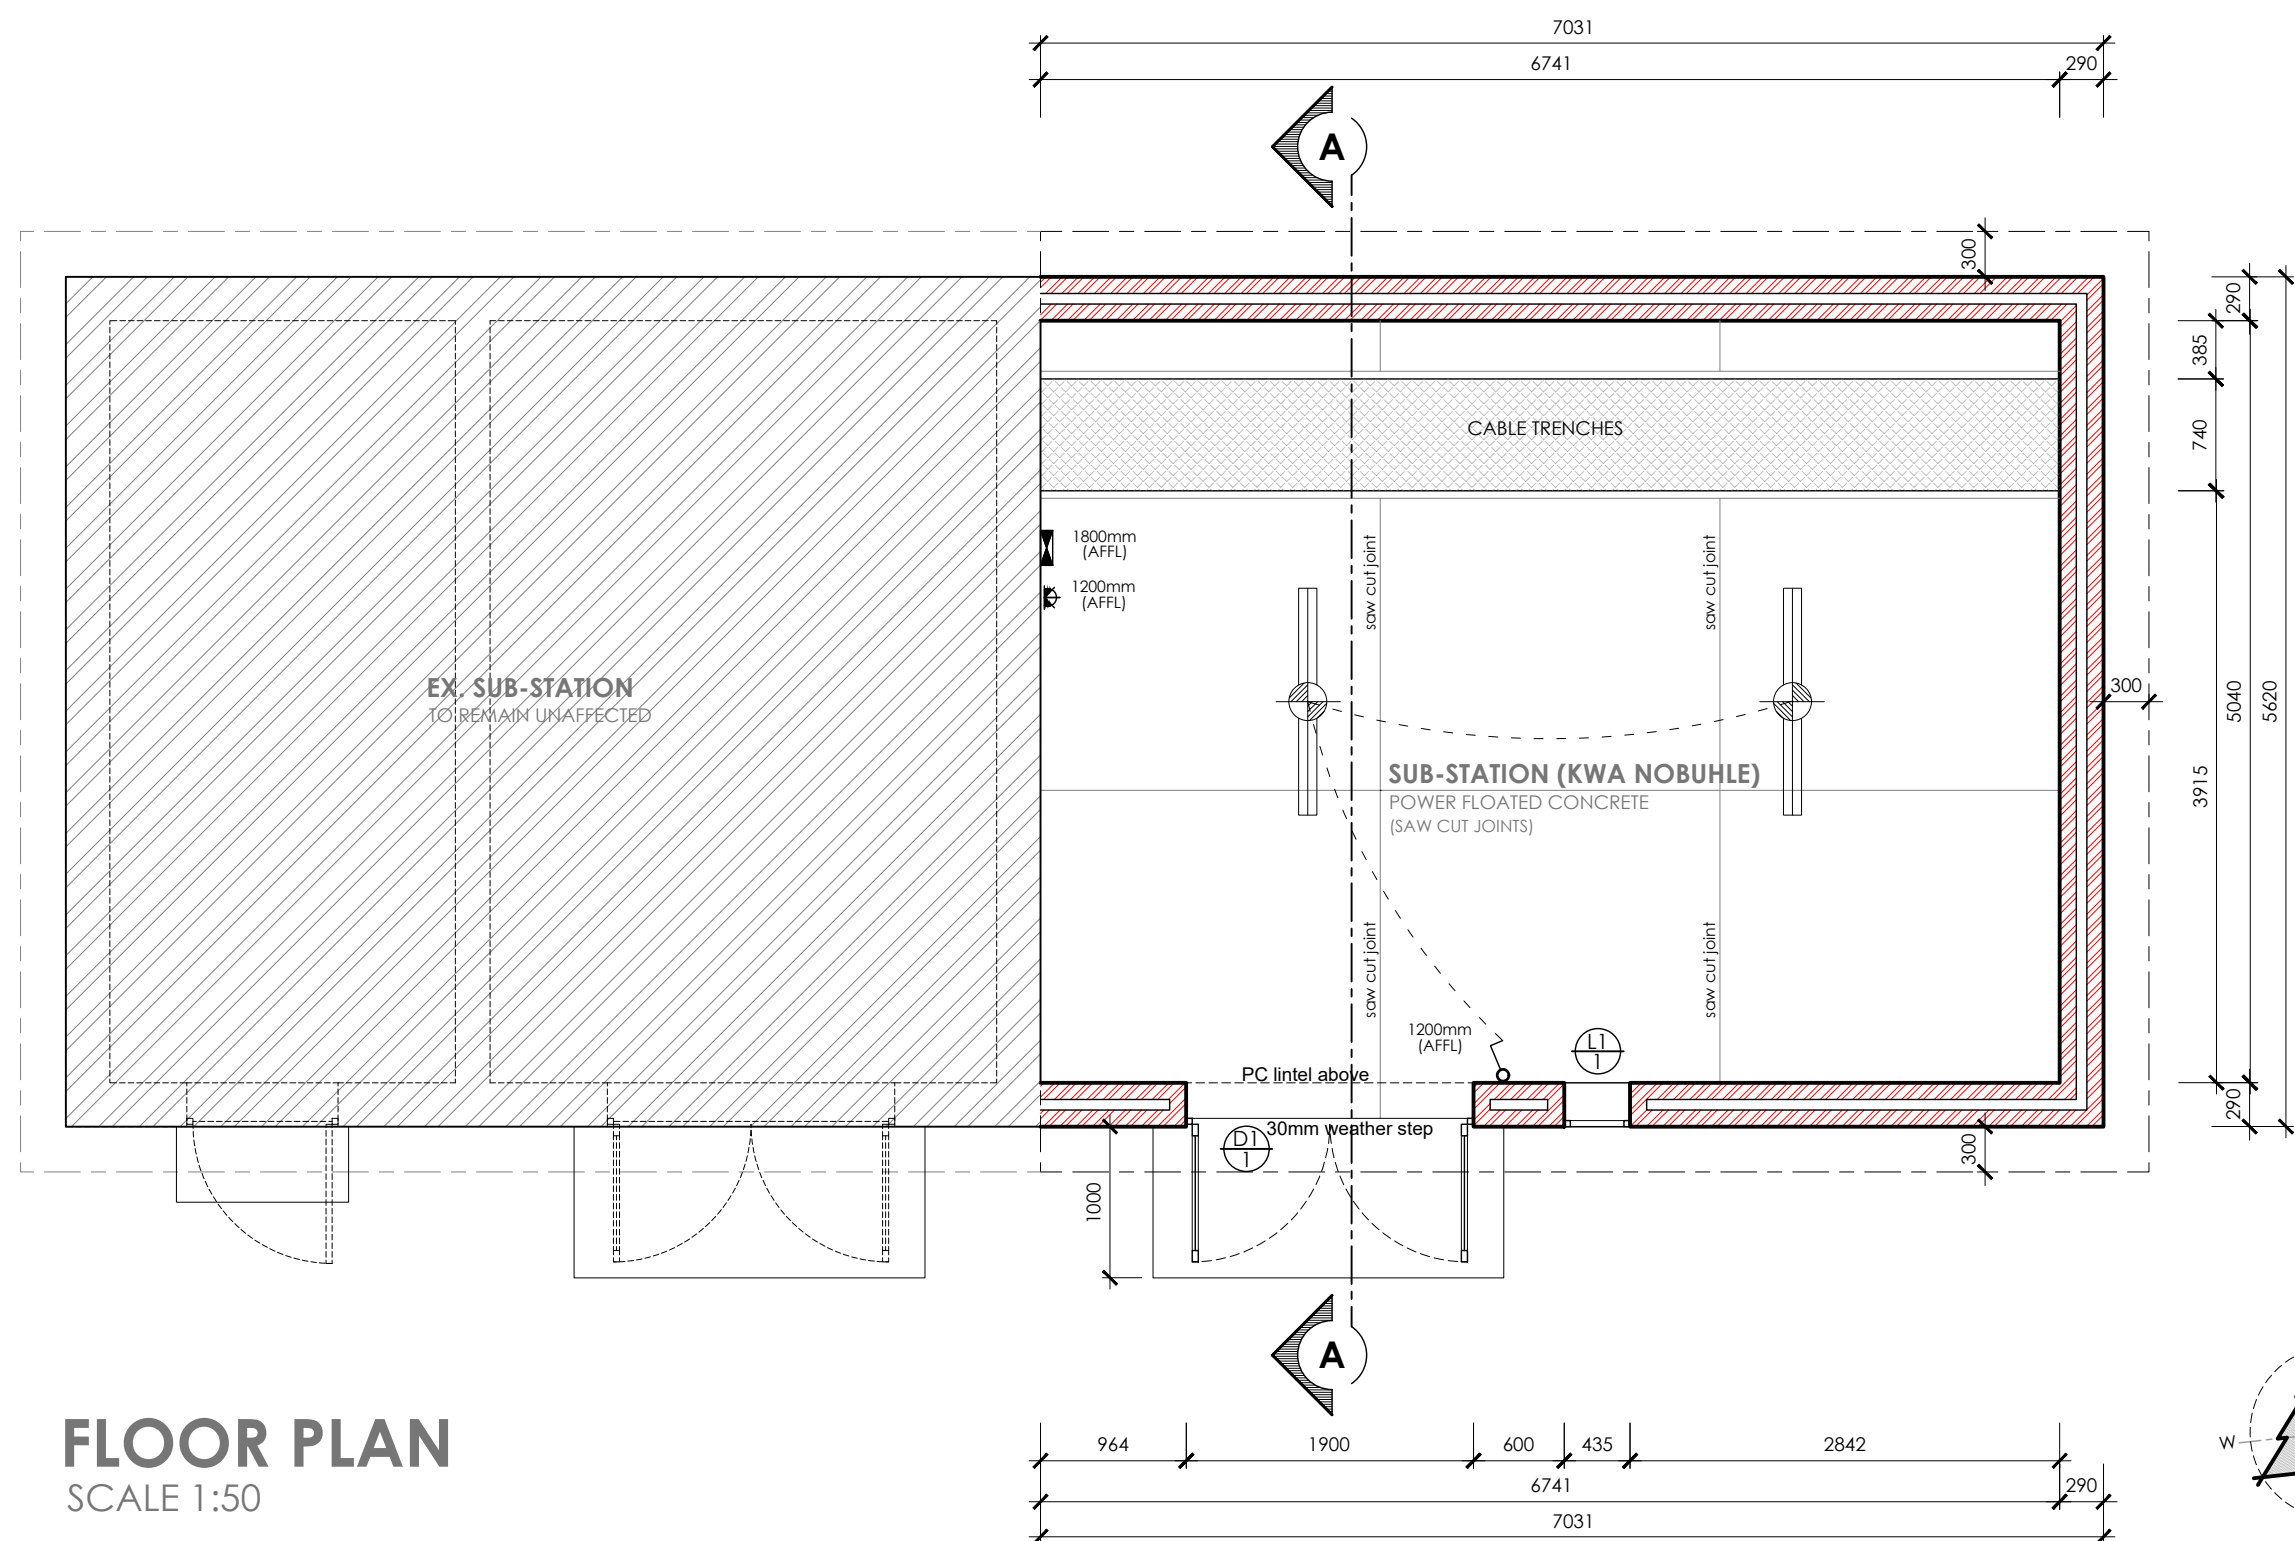

ELECTRICAL LEGEND			
	Single wall mounted light switch to be mounted at 1300mm above uflt.		(2 x 18 W) 1500 Long 2 tube fluorescent armature with prismatic diffuser suspended from ceiling.
	Double wall mounted light switch to be mounted at 1300mm above uflt.		(10 Watt x 2) External LED Wall mounted light
	Triple wall mounted light switch to be mounted at 1300mm above uflt.		Main distribution board
	2-way wall mounted light switch to be mounted at 1300mm above uflt.		Daylight sensor
	Waterlight wall mounted light switch to be mounted at 1300mm above uflt.		
	Dimmer wall mounted light switch to be mounted at 1300mm above uflt.		
	Double wall mounted plug, top of socket to be T250mm above uflt.		
	Double wall mounted plug, top of socket to be 300mm above uflt.		
	Double wall mounted waterlight plug		
	Extractor connection plug @ 2100mm		
	Blank conduiting boxes		
	Periscope plug as per specification.		
	Garage door ceiling mounted motor		

FINISHES	
EXTERNAL WALLS	NEW FACEBRICK TO BE RECESS POINTING AND TO MATCH EXISTING BY SPECIALIST.
INTERNAL WALLS	2 COATS OF 'DULUX ACRYLIC PVA BRILLIANT WHITE' ON PLASTERED WALLS
CONCRETE FLOOR	POWER FLOATED CONCRETE FINISH WITH 1MM TOLERANCE.
FACEBRICK	TO MATCH EXISTING FACEBRICK

D1 - quantity 1

ALL DIMENSIONS TO BE TAKEN ON SITE

DOOR NO.	D1
QUANTITY:	1
SIZE:	1900mm x 2465mm
TYPE:	GALVANIZED TRANSFORMER COVER DOOR BY SPECIALIST.
FINISH:	QUALITY TRANSFORMER COVER WITH EXTERNAL QUALITY GALVANIZED TRANSFORMER OR EQUIVALENT APPROVED
FRAME:	FRAME WITH DOOR INCLUDING DOWN TRAMAL LOGS FIXED AT ALL C/C ON OUTSIDE OF FRAME
FRAME:	GALVANIZED FRAME PAINTED WITH EXTERNAL QUALITY GALVANIZED TRANSFORMER OR EQUIVALENT APPROVED
IRON/MONTERY:	STAINLESS STEEL HINGES, HOOKS & LATCHES AS PER SUPPLIER SPECIFICATIONS. RUBBER DOOR SEAL TO BOTTOM OF FRAME INCLUDING WEARSTRIP FAST & AS LOW AS POSSIBLE DOOR & FRAME.

L1 - quantity 7

ALL DIMENSIONS TO BE TAKEN ON SITE

LOUVER NO.	L1
QUANTITY:	1
SIZE:	435mm x 850mm x 100mm
DESCRIPTION:	8 BLADES ALUMINUM WITH 40MM UP V-BLADES WEATHER COVER
FINISH:	POWDER COAT FINISH EXTERNAL QUALITY TO MATCH DOOR TRANSFORMER OR EQUIVALENT APPROVED
BIRD PROOFING:	3.0mm TRANSFER RESISTENT PROOF FIXED TO INSIDE OF LOUVER

[illegible]

GENERAL NOTES

[illegible]

DRAWING TITLE:

CONSTRUCTION

PROJECT TITLE

NEW SUBSTATION ON ERF 1, KWANOBUHLE, PORT ELIZABETH FOR Werner Badenorf

7 Jul 25

.....

CLIENT SIGNATURE

bh **BLACKHOUND**
ARCHITECTURE & RENDERING

dewald@blackhoundenterprises.com
072 799 9597 | 072 418 6867
<https://blackhoundenterprises.com>
Unit 10, The Network, 19 Cactus Rd
Fairview, Port Elizabeth, 6070

.....
PROFESSIONAL SIGNATURE

MUNICIPAL INFORMATION:

ERF NO:	1, KwaNobuhle
ERF AREA:	833397.35 sqm
EXISTING AREA:	36.22 sqm
NEW AREA:	39.51 sqm
TOTAL AREA:	75.73 sqm
EX. COVERAGE:	36.22 sqm - 0.00%
NEW COVERAGE:	39.51 sqm - 0.00%
TOTAL COVERAGE:	76 sqm - 0%
NEW GARAGES:	0
NEW BATHROOMS:	0
POOL:	NO
BOUNDARY WALLS:	0 M
AGE OF BUILDING:	<60


PROFESSIONAL ARCHITECTURAL TECHNOLOGIST
DEWALD MATHYS POTGIETER
 17:34 pm (Africa/Johannesburg) on 07 Jul 2025

COPYRIGHT:

This drawing is subject to copyright, and may not be reproduced in whole or part in any matter whatsoever without written permission from Blackhound Architecture & Rendering.

PROJECT NO.: 2025_SubStation_02	REVISION NO.: 00
DRAWING NO.: 20250707_SubStation_MS01	SHEET NO.: 101
DRAWN BY: DMP	
PRINT DATE: 07 Jul 2025	PAGE SIZE: A1