




scale 1 : 100 | **G/F ELECTRICAL & WATER** DEVIATION POINT 23: ELECTRICAL LAYOUT UPDATED AS PER SITE MEASUREMENTS

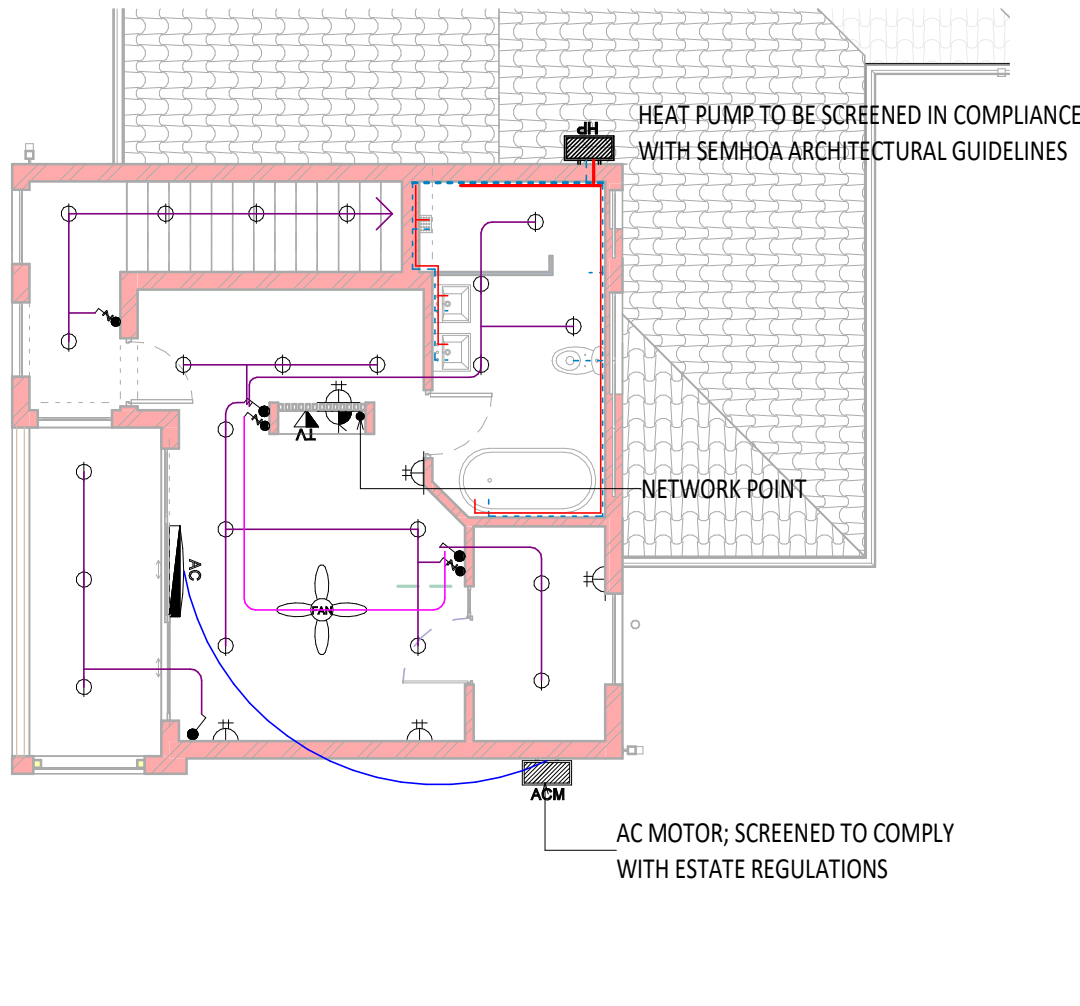

scale 1 : 100 | **F/F ELECTRICAL & WATER** DEVIATION POINT 23: ELECTRICAL LAYOUT UPDATED AS PER SITE MEASUREMENTS

6 - Electrical Equipment Schedule		
sym.	Description	Count
	200L Geyser	1
	1500 Fluorescent Light Fitting	1
	Ceiling Fan	5
	Distribution Board	2
	Double 15amp plug 1200mm above ffl	5
	Double 15amp plug 355mm above ffl	17
	Garden Light Fitting.	4
	Hanging lights	6
	Heat pump	1
	Incandescent Ceiling Light	1
	Min Downlighter Low Voltage Recessed Multi Groove	59
	Pendant lights	1
	Pool Light	1
	Pool Motor	1
	single 15 amp plug 1200mm above ffl	2
	Single 15amp plug ceiling mounted	6
	Single pole switch	7
	single pole two way switch	3
	Square wall light plastic in black finish	2
	Stove Point	2
	Three pole switch.	2
	TV arial connected to satalite	4
	Two pole switch	8
	Two pole two way switch	5
	Wall mounted A/C unit	4
	Wall Mounted Aircon Motor	3
	Wall Mounted Light with dayl light sensor switch	7

- LIST OF DEVIATIONS (FROM PREVIOUSLY APPROVED):**
- WALL THICKNESS DEVIATED
 - INTERNAL DIMS OF ROOM AMENDED AS PER SITE DIMENSIONS
 - BRAAI OMITTED; REVERT BACK TO ORIGINAL APPROVED PATIO
 - SLIDING DOOR CHANGED TO WINDOW
 - SLIDING DOOR DEVIATED
 - WINDOW DEVIATED
 - WINDOW OMITTED
 - YARD DEVIATED
 - SCREEN WALL DEVIATED
 - NEW TIMBER SCREEN
 - EN-SUITE 2 DEVIATED
 - STAIRS DEVIATED
 - POOL DEVIATED
 - FIRST FLOOR WALLS AMENDED TO BE ON TOP OF EXISTING GARAGE WALLS
 - EN-SUITE DEVIATED
 - DRESSING ROOM DEVIATED
 - DRIVEWAY EXTENSION DEVIATED
 - NEW WINDOW
 - ROOF DEVIATED/AMENDED AS PER SITE MEASUREMENTS
 - PERGOLA DEVIATED/AMENDED AS PER SITE MEASUREMENTS
 - NEW GARAGE DOOR
 - AREA SCHEDULE UPDATED AS PER ON SITE MEASUREMENTS
 - ELECTRICAL LAYOUTS UPDATED AS PER SITE MEASUREMENTS
 - FIRST FLOOR FRAME DEVIATED

THIS DRAWING AND DESIGN IS SUBJECT TO COPYRIGHT AND MAY NOT BE REPRODUCED IN WHOLE OR PART OR IN ANY MANNER WHATSOEVER WITHOUT WRITTEN PERMISSION FROM CORNEL CLOETE ARCHITECTS AND PROJECT MANAGERS.

COUNCIL STAMP

10	03/10/2023	1. CHANGES AS PER CLIENT FEEDBACK; 2. ISSUE TO CLIENT
NO	DATE	DESCRIPTION
REVISION SCHEDULE		

ESTATE STAMP

ARCHITECT

REGISTERED PROPERTY OWNER

CCA
CORNELCLOETE
architects and project managers

DIRECTOR: CORNEL CLOETE | SACAP: PR.ARCH 24743077 | Po.Box 6461 Zimballi 4418
OFFICE: 032 538 1089 | MOBILE: 082 322 1405 | cornel@ccarch.co.za

PROJECT:
PROPOSED ALTERATIONS AND ADDITIONS ON LOT 2399 SEAWARD AT 21 SAN LORENZO SEAWARD ESTATE

CLIENT: D.M. WILSON & N.G.A. GEDEN

DRAWING DESCRIPTION:
ELECTRICAL AND WATER RETICULATION

BUILDING CLASSIFICATION: H4

AUTHOR: M. NAUDE - PSAT 46036820

CHECKED BY: _____

WORKING DRAWINGS

PROJECT NO. CCA23/015 **P/A PLAN NO:** 22/04/229

DRAWING NO. KZN23-DEV02-201 **SHEET:** 4 OF 7

DATE: 2023/10/03 06:53:45 **REVISION:** 10